

General Notes

- Owner and Developer:
Williamsport Properties, Inc.
1500 Sycamore Road
Montoursville, PA 17754
 - Zoned - '1-2' Heavy Industrial
 - Minimum Lot Size - 3 Acres, 150' Wide
 - Building Setbacks:
Front Yard - 100' from Centerline of Road or 75' from ROW (whichever is greater)
Side Yard - 20' each side
Rear Yard - 30' principal structure; 10' accessory structure

Minimum Lot Width - 150'
Max. Bldg. Height - 30'
Max. Bldg. Coverage - 50%
 - Soil boundaries and types as shown taken from Lycoming County GIS Data
 - Soils Types:
DuB-Duncannon Loam, 3-8% slopes *
TuC-Tunkhannock gravelly loam, 8-15% slopes
WsA-Wheeling Silt Loam, 0-3% slopes*
- * Prime Ag Land
- Sewage Service is being provided by a public sewage system. Water Service is being provided by public water supply
 - Stormwater Management will be by a Stormwater Infiltration Swale and Infiltration Pond.
 - An NPDES Permit is not required
 - Municipalities may require a permit to access municipal roads.
 - The erosion and sediment control plan will be submitted to the Lycoming County Conservation District. No Land Disturbance is Permitted until the Conservation District has approved the plan.
 - Parking Requirements - (1) for each 2 employees

Proposed Building



For

Williamsport Properties, Inc.


Muncy Creek Township

Lycoming County

Commonwealth of Pennsylvania

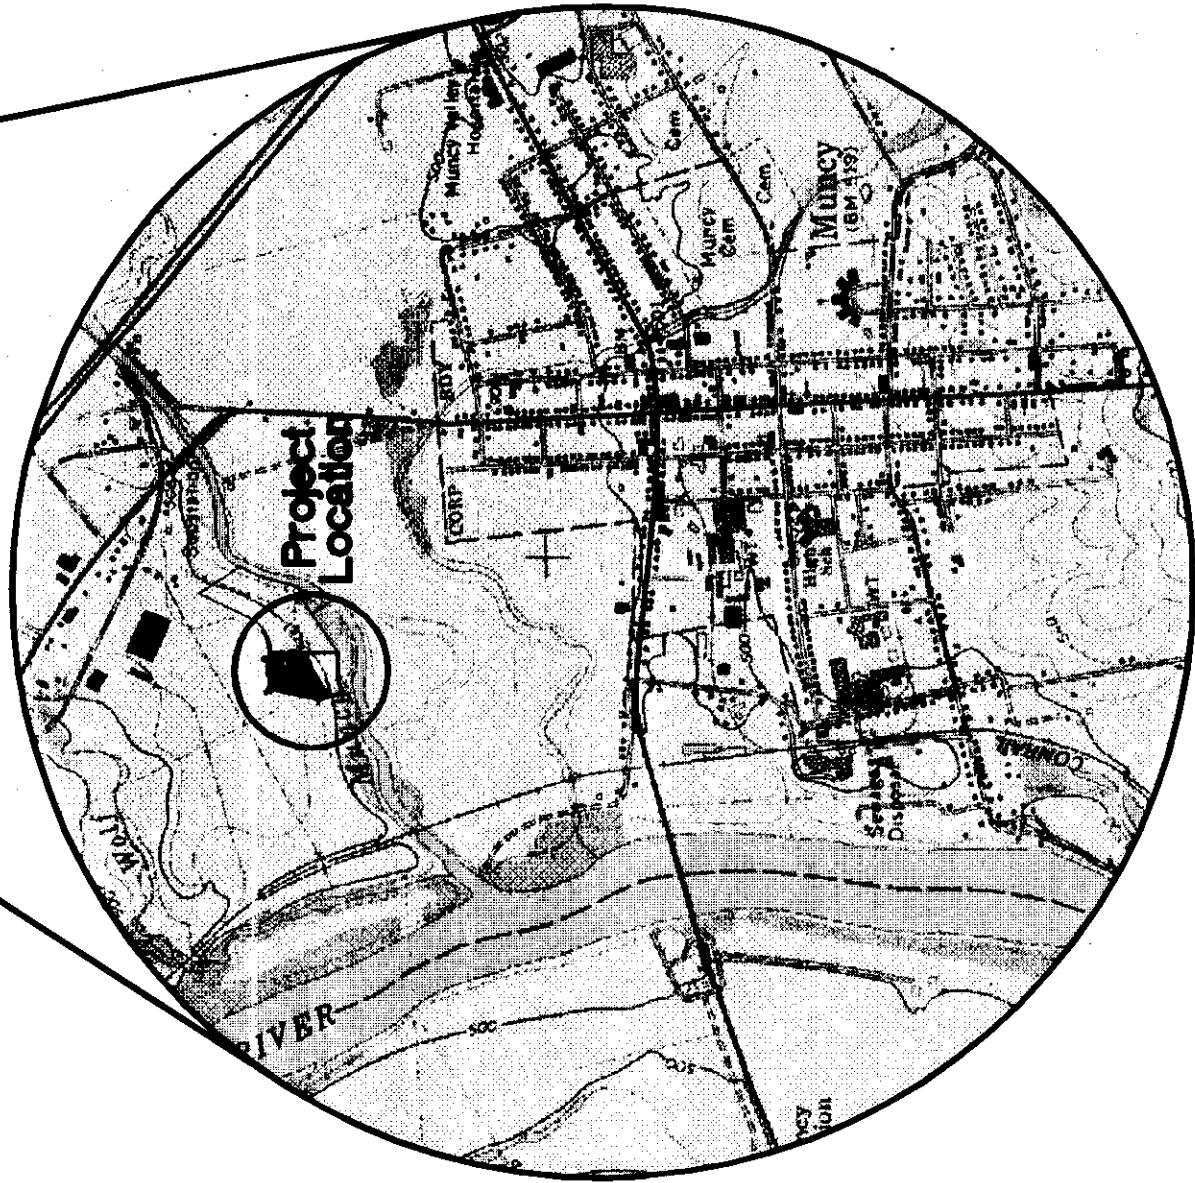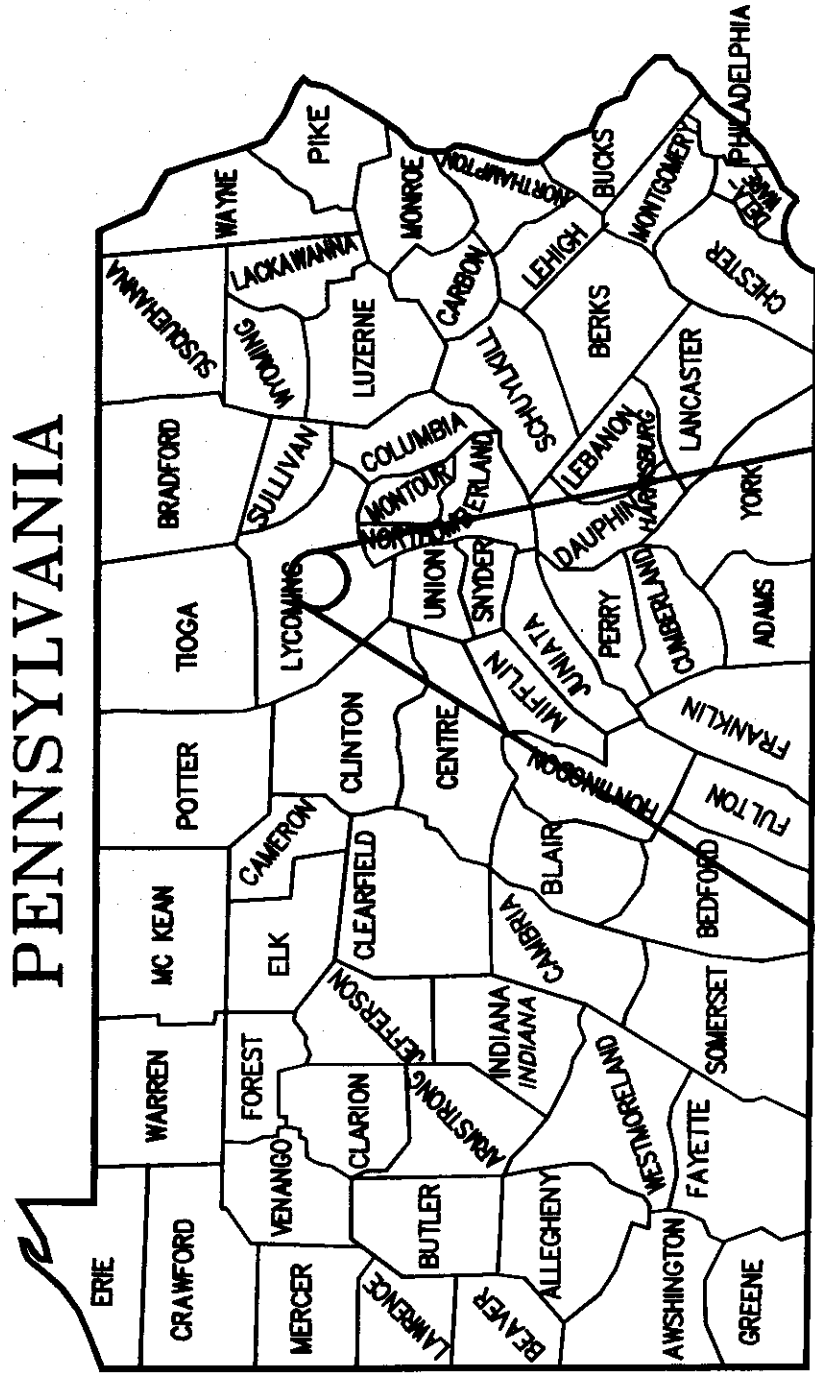

Location Map
Portion Of U.S.G.S.
Muncy Quadrangle

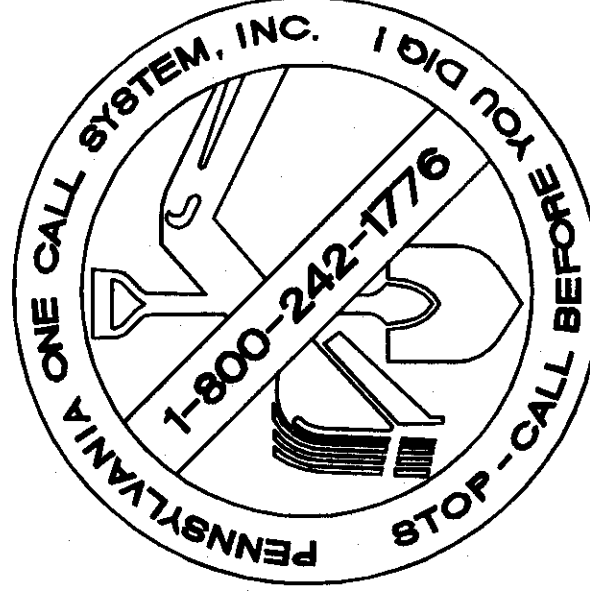

Pennsylvania One Call System, Inc.
Call Before You Dig!
1-800-242-1776
Design Serial # 3156928

A representative of Glenn O. Hawbaker Incorporated has surveyed the project site, and prepared this Plan. Each page of this Plan contains the EXCLUSIVE WORK PRODUCT of Glenn O. Hawbaker, Incorporated. Thus, this Plan is the EXCLUSIVE WORK PRODUCT of Glenn O. Hawbaker, Incorporated. THIS PLAN IS NOT TO BE DIVULGED, IN PART OR WHOLE, TO OTHER PERSONS OR COMPETITORS, OR MADE PUBLIC IN ANY WAY WITHOUT PRIOR WRITTEN CONSENT FROM GLENN O. HAWBAKER, INCORPORATED.

This Plan is not to be copied in any manner. The drawings, photographs and specifications are the Work Product and Property of Glenn O. Hawbaker Inc.. This Plan is not to be divulged, in part or whole, to other persons or competitors, or made public in any way WITHOUT PRIOR WRITTEN CONSENT FROM GLENN O. HAWBAKER, INCORPORATED.

Submission or distribution necessary to get budget, financial approval, construction permit, or meet other regulatory requirements for this Project, is not to be construed as publication or dedication of Glenn O. Hawbaker, Incorporated's copyright or other reserved rights.

Glenn O. Hawbaker, Incorporated reserves to itself the exclusive rights for construction of the Work described in this Plan.

Proposed Building

For

Williamsport Properties, Inc.

Muncy Creek Township
Lycoming County
Commonwealth of Pennsylvania



Sheet Name

Cover Sheet

1 of 4

SILT FENCE

CONSTRUCTION ENTRANCE

ROCK OUTFALL

TOPSOIL STOCKPILE

VEGETATED FILTER STRIP

EXISTING CONTOURS

PROPOSED CONTOURS

SOIL BOUNDARY LINE

SOIL TYPE

**LIMIT OF DISTURBANCE/NPDES
PERMIT BOUNDARY**

Proposed Building

For

Williamsport Properties, Inc.

**Muncy Creek Township
Lycoming County
Commonwealth of Pennsylvania**

Hawbaker
Construction Services
Eastern Region

Drafter	C.J. Stein
Checker	C.A. Loque, P.E.

Scale	1"=50'
Date	11/11/08

Revisions	11/17/08
Owner	11/17/08

Owner	11/11/00
-------	----------

Sheet Name:

Existing Conditions

2 of 4

INFILTRATION SWALE

B 800 P 204

Grading Plan

SCALE: 1"=50'


SCALE: 1 = 50

GRAPHIC SCALE

(IN FEET)

1 inch = 50 ft.


3 of 4

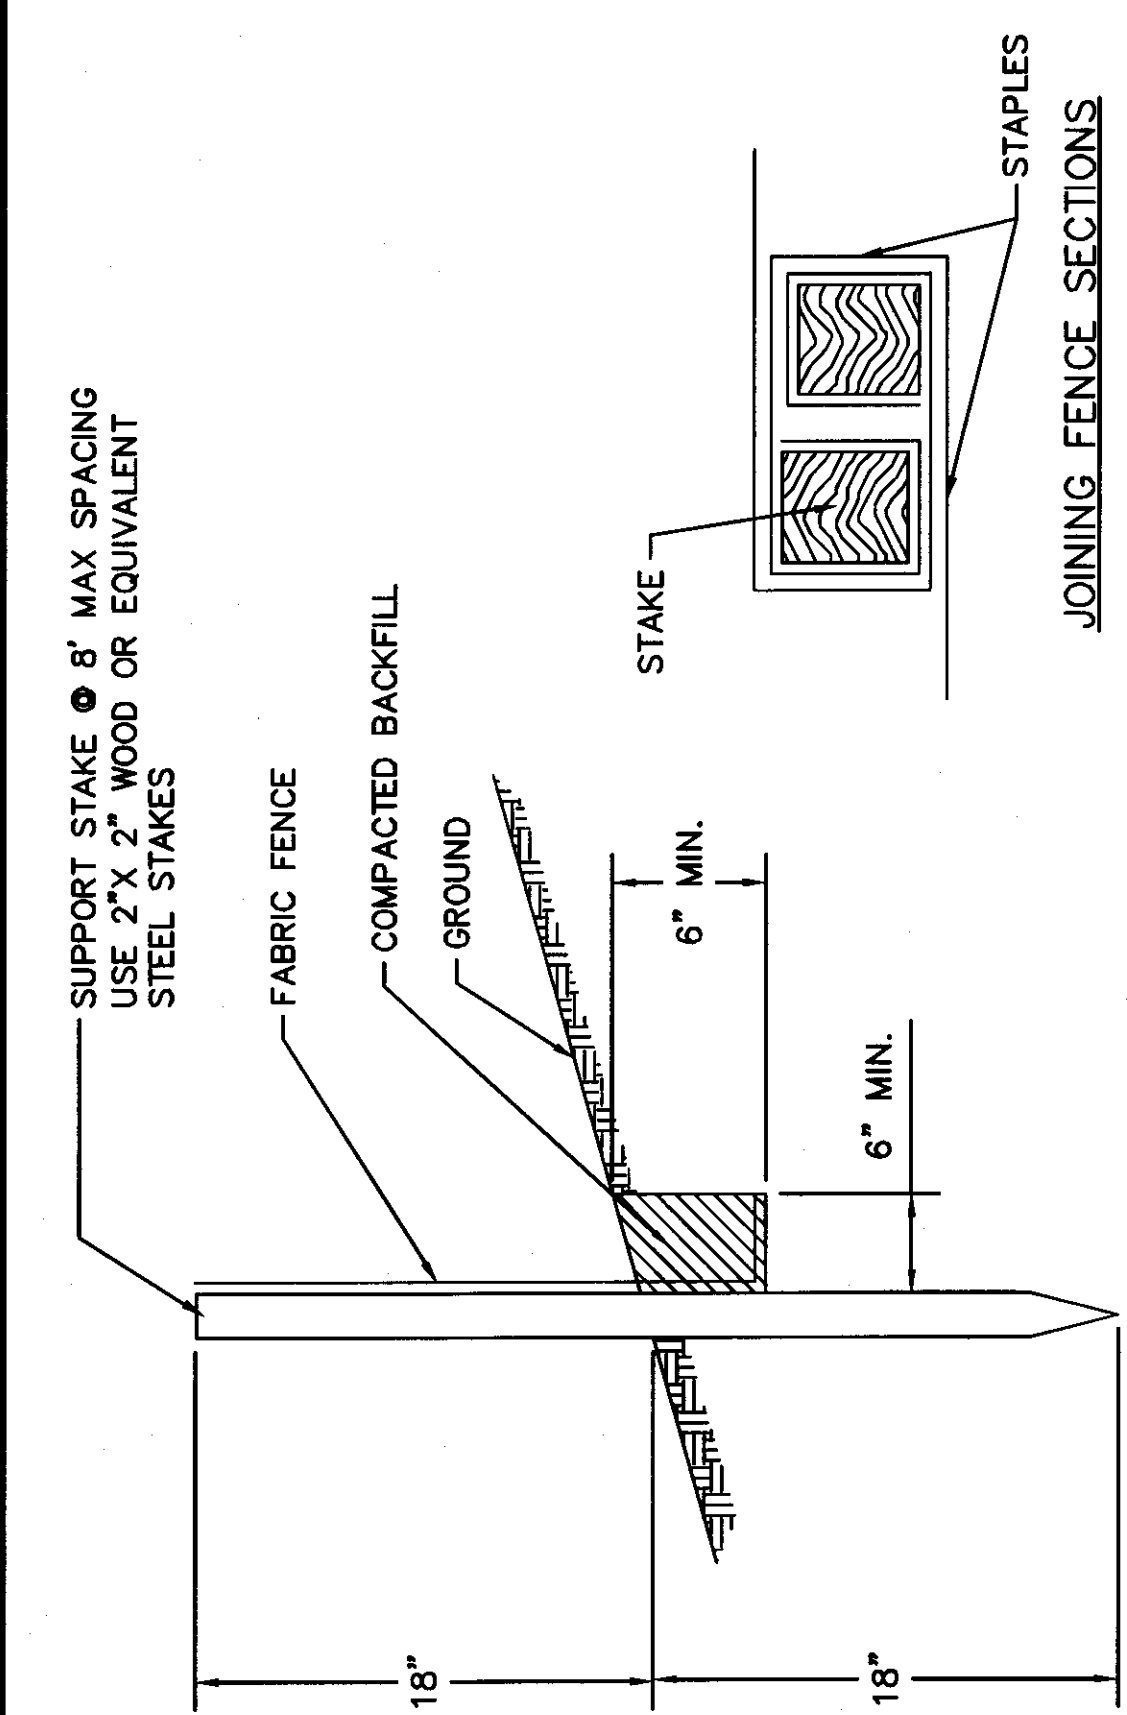

INSTALLATION


1. FILTER FABRIC FENCE SHOULD BE INSTALLED AT LEVEL GRADE. BOTH ENDS OF EACH FENCE SECTION SHOULD BE EXTENDED AT LEAST 3 FEET UP SLOPE AT 45 DEGREES TO THE MAIN FENCE ALIGNMENT TO ALLOW FOR POOLING OF WATER.
 2. A 6" DEEP TRENCH SHOULD BE EXCAVATED, MINIMIZING THE DISTURBANCE ON THE DOWNSLOPE SIDE. THE BOTTOM OF THE TRENCH SHOULD BE AT LEVEL GRADE. MAXIMUM DEVIATION FROM LEVEL GRADE SHOULD BE 1% AND NOT EXTEND FOR MORE THAN 25 FT.
 3. SUPPORT STAKES SHOULD BE DRIVEN 18" BELOW THE EXISTING GROUND SURFACE AT 8 FOOT (MAX.) INTERVALS.
 4. FILTER FABRIC SHOULD BE STRETCHED AND FASTENED TO THE UPSLOPE SIDE OF THE SUPPORT STAKES. WHENEVER REINFORCED FABRIC FENCE IS INSTALLED, THE REINFORCEMENT MESH SHOULD BE FASTENED TO THE STAKES PRIOR TO THE FABRIC.
 5. AT FABRIC ENDS, BOTH ENDS SHOULD BE WRAPPED AROUND THE SUPPORT STAKES AND STAPLED. IF THE FABRIC COMES ALREADY ATTACHED TO THE STAKES, THE END STAKES SHOULD BE HELD TOGETHER WHILE THE FABRIC IS WRAPPED AROUND THE STAKES AT LEAST ONE REVOLUTION PRIOR TO DRIVING THE STAKES.
 6. THE BOTTOM OF THE FENCE SHOULD BE ANCHORED BY PLACING THE FABRIC IN THE BOTTOM OF THE TRENCH, AND BACKFILLING AND COMPACTING THE FILL MATERIAL IN THE TRENCH.
- MAINTENANCE
1. THE FENCE INSTALLATION SHOULD BE INSPECTED AFTER EVERY PRECIPITATION EVENT. ANY NECESSARY REPAIRS WILL BE MADE IMMEDIATELY
 2. ACCUMULATED SEDIMENTS WILL BE REMOVED AS REQUIRED TO KEEP THE FENCE FUNCTIONAL. IN ALL CASES, REMOVE DEPOSITS WHERE ACCUMULATIONS REACH 1/2 THE ABOVE GROUND HEIGHT OF THE FENCE.
 3. ALL UNDERCUTTING OR EROSION OF THE TOE ANCHOR WILL BE PREPARED IMMEDIATELY WITH COMPACTED BACKFILL MATERIALS.
 4. ADHERE TO ANY MANUFACTURER'S RECOMMENDATIONS FOR REPLACING FABRIC FENCE DUE TO WEATHERING.
 5. ANY SECTION OF FILTER FENCE WHICH HAS BEEN UNDERMINED OR TOPPED MUST BE IMMEDIATELY REPLACED WITH A ROCK FILTER OUTLET.

STANDARD FILTER FABRIC FENCE (18" HIGH)

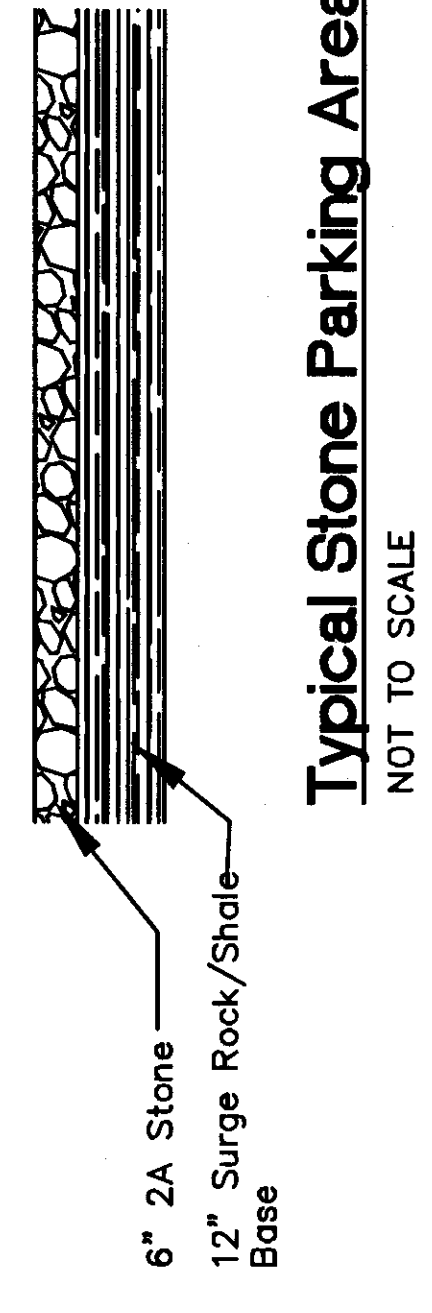


Typical Stone Parking Area



NOT TO SCALE

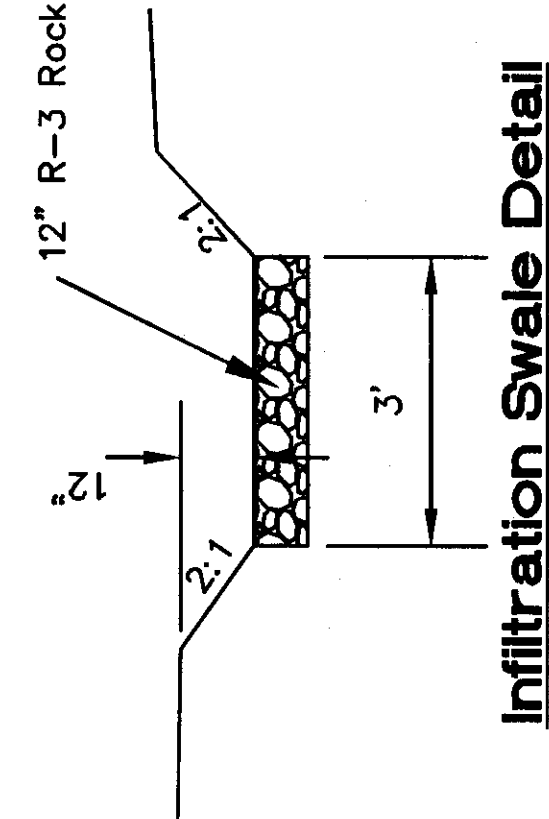

Infiltration Swale Detail

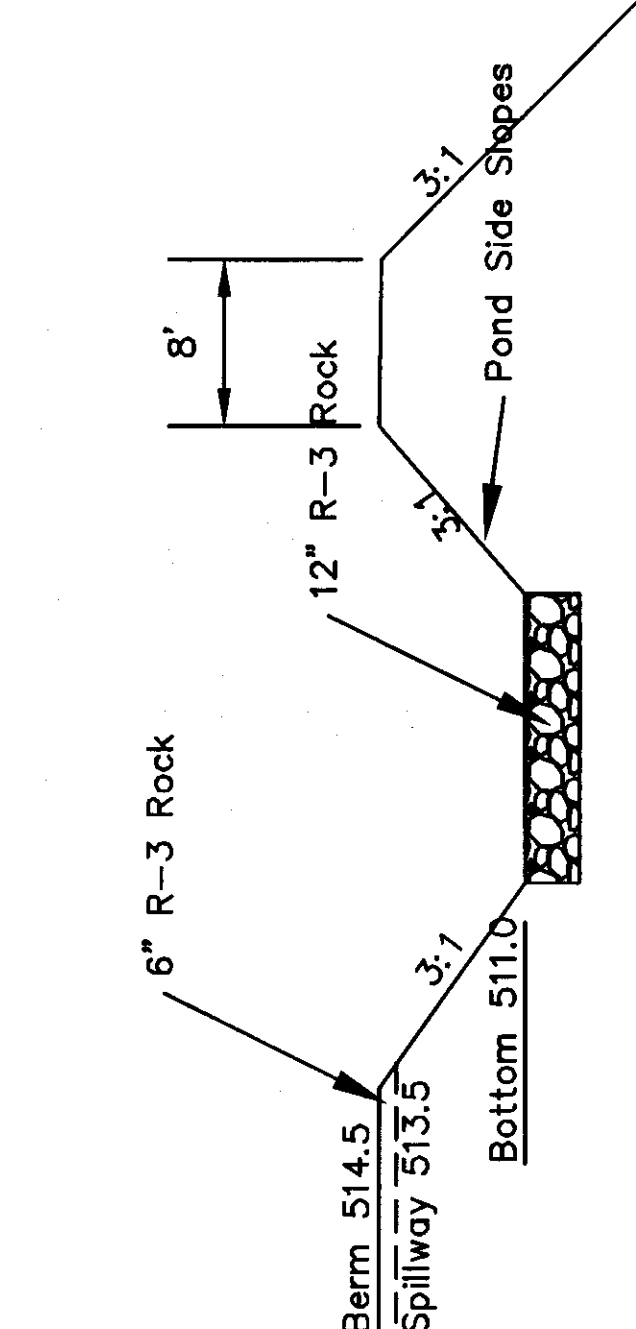


Infiltration Pond Detail

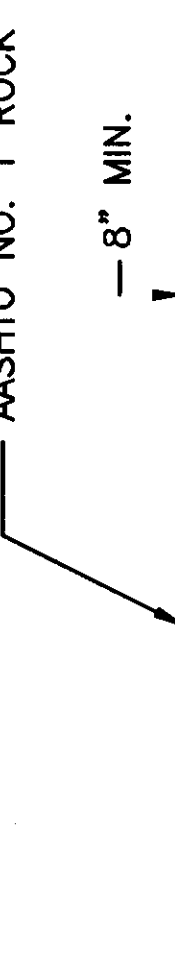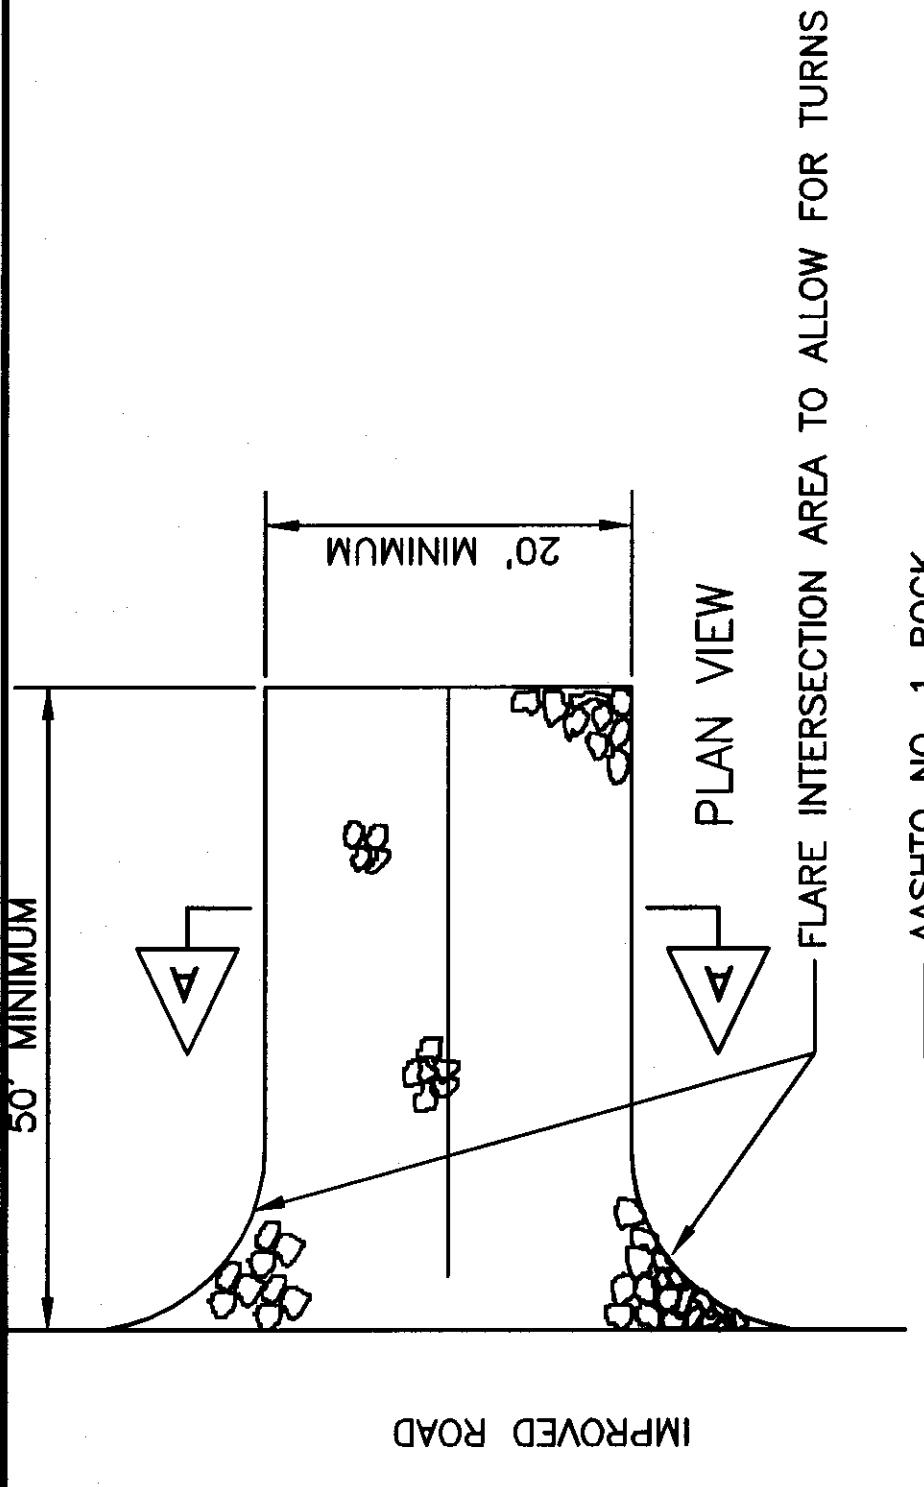

ROCK CONSTRUCTION ENTRANCE

NOT TO SCALE

- CONSTRUCTION ENTRANCE MAINTENANCE:
1. THE STRUCTURE'S THICKNESS WILL BE CONSTANTLY MAINTAINED TO THE SPECIFIED DIMENSION BY ADDING ROCK. A STOCKPILE OF ROCK MATERIAL WILL BE MAINTAINED ON THE SITE FOR THIS PURPOSE. AT THE END OF EACH CONSTRUCTION DAY, ALL SEDIMENT DEPOSITED ON PUBLIC ROADWAYS, WILL BE REMOVED AND RETURNED TO THE CONSTRUCTION SITE. WASHING OF THE ROADWAY IS NOT PERMITTED. REMOVE AND RESTORE AREA UPON COMPLETION OF PROJECT.

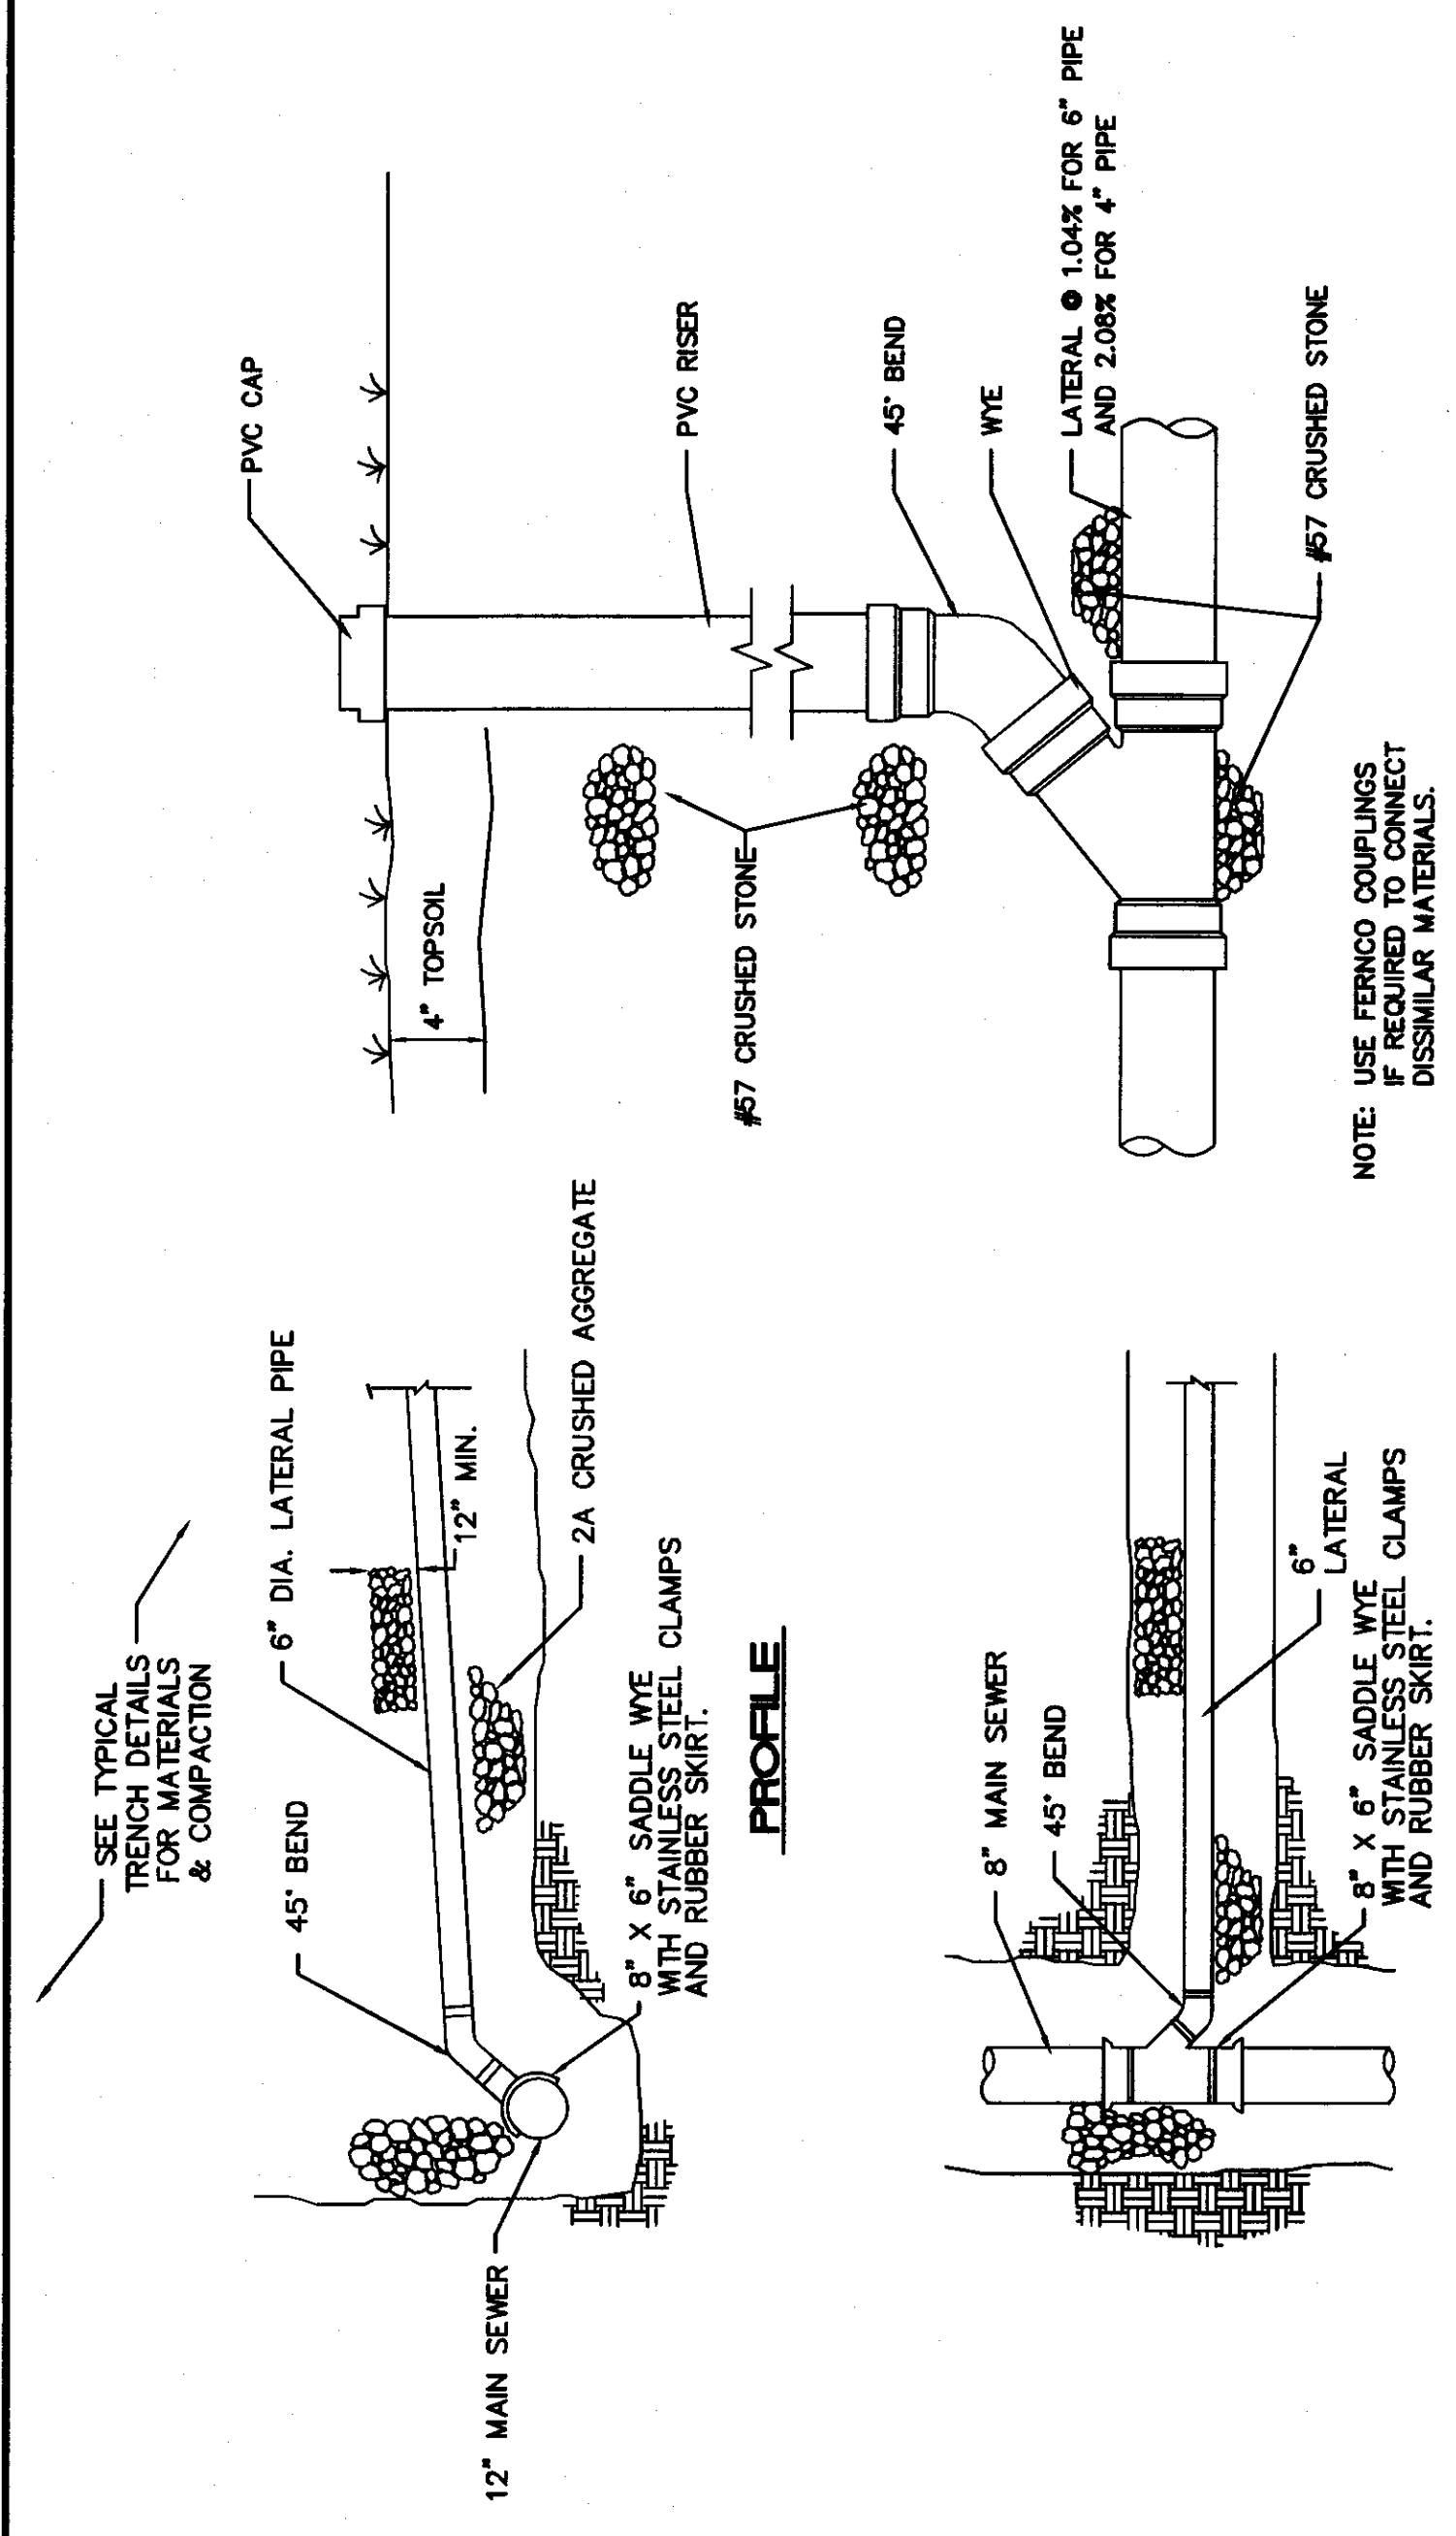


PROFILE

PLAN

LATERAL DETAIL

CLEANOUT
NOT TO SCALE

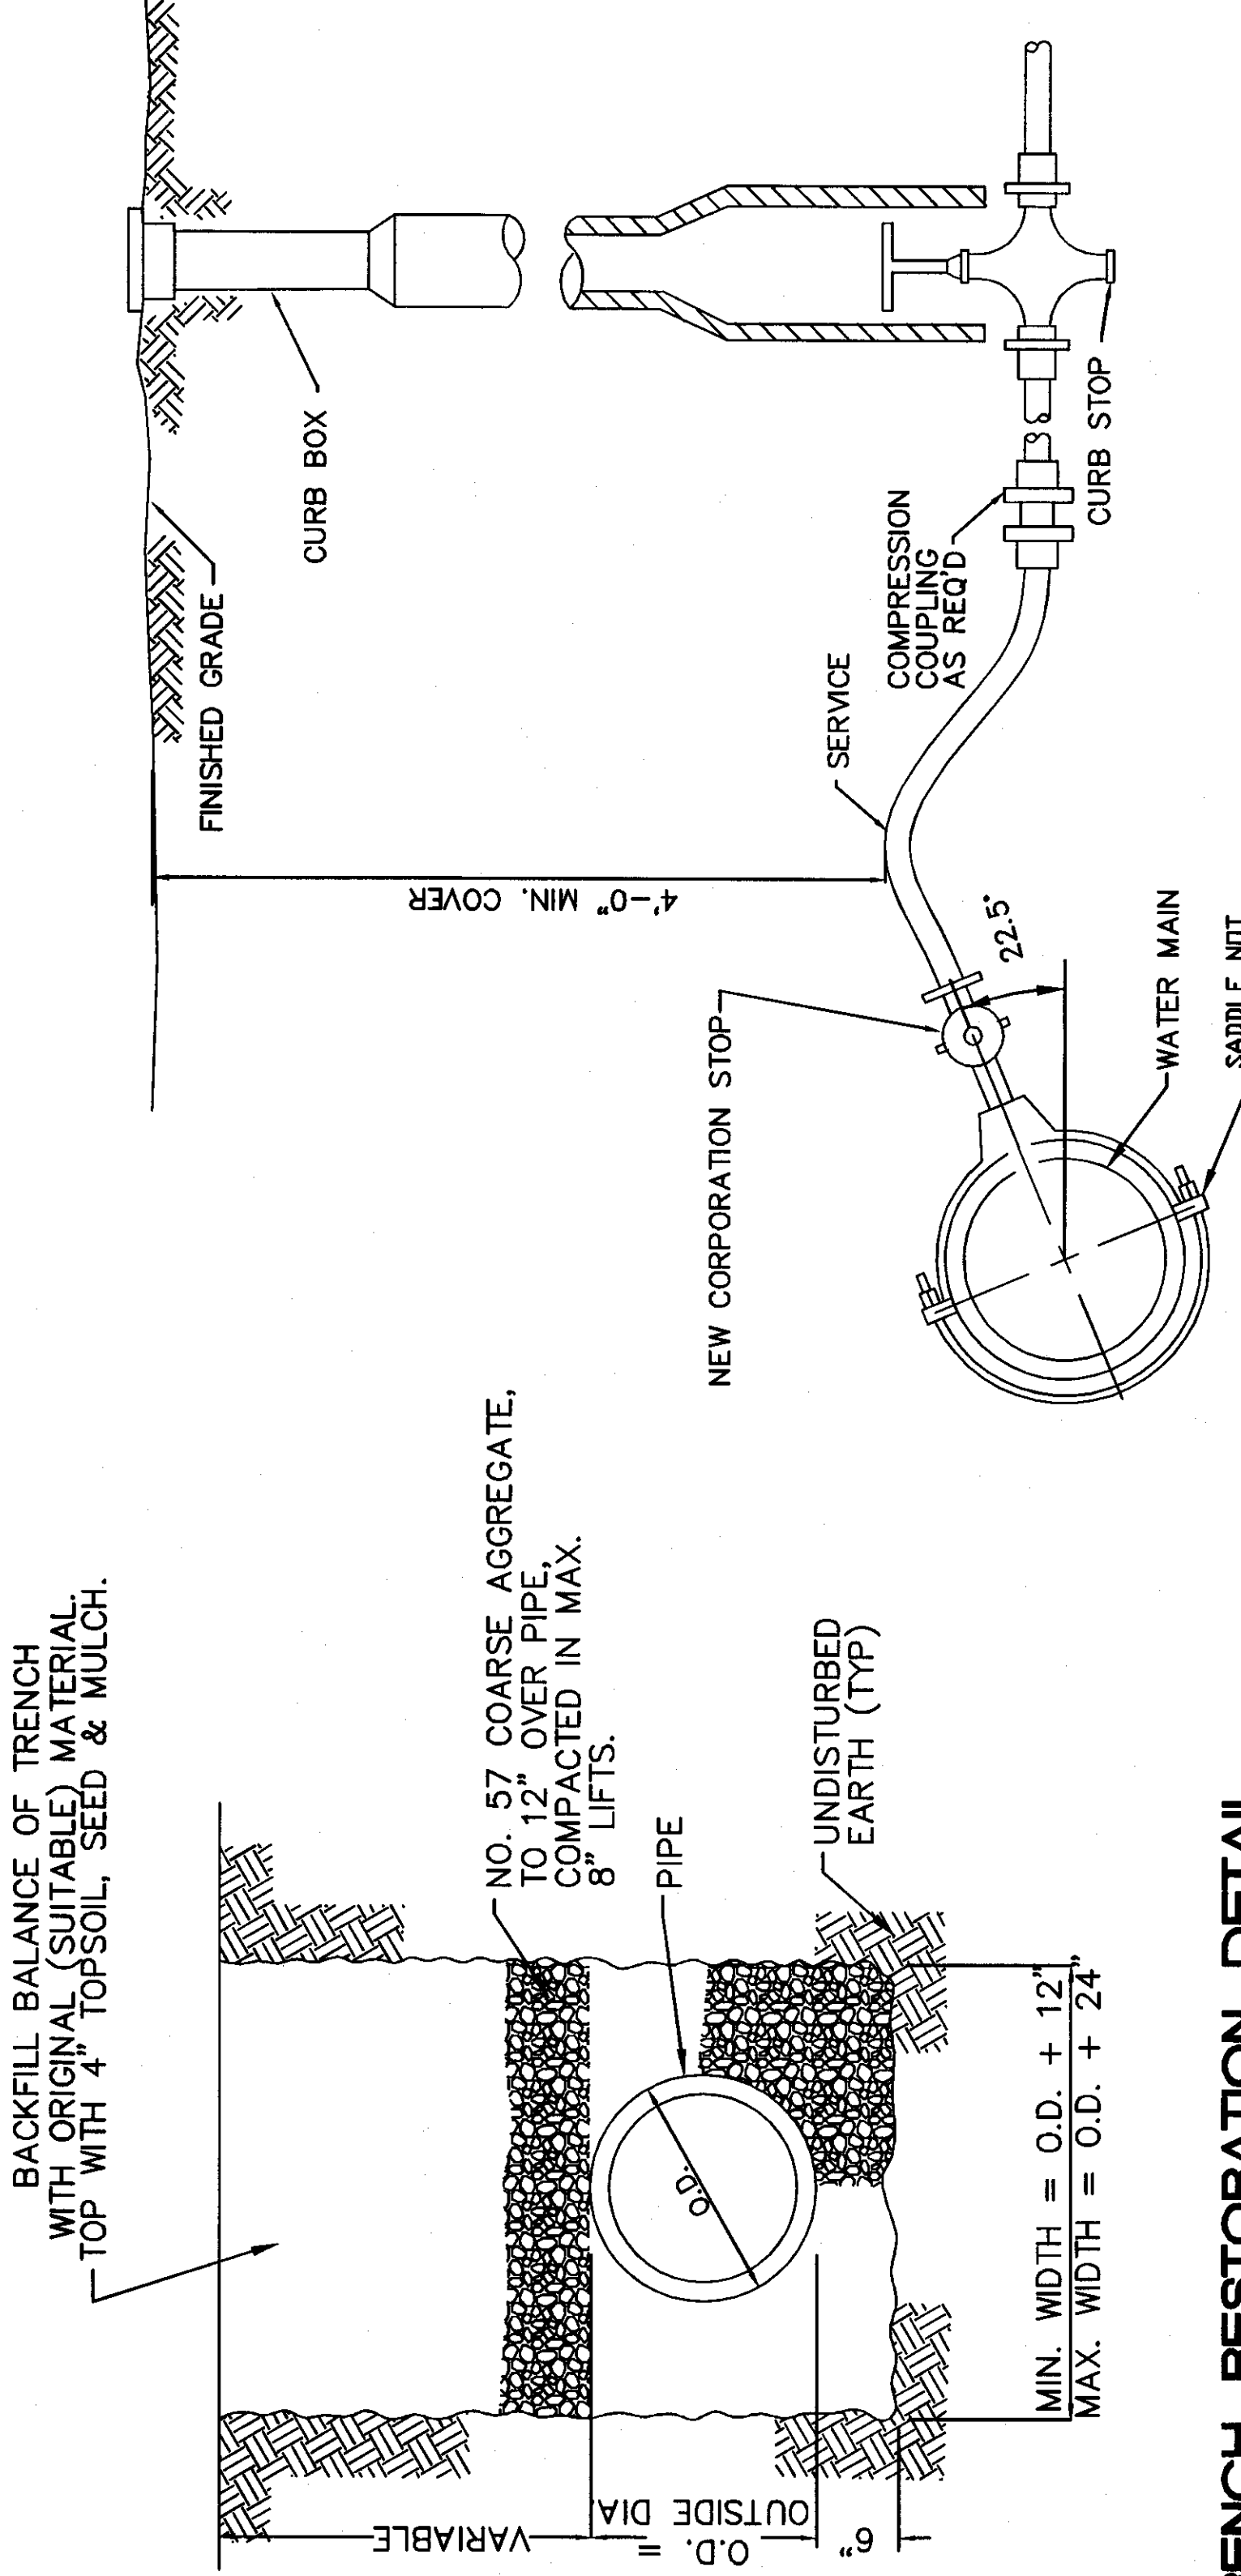

TRENCH RESTORATION DETAIL

LAWN AREAS

SERVICE INSTALLATION PROFILE
NOT TO SCALE

Proposed Building

For

Williamsport Properties, Inc.

Muncy Creek Township
Lycoming County
Commonwealth of Pennsylvania



Eastern Region
2801 Carlisle Lane
Montourville, PA 17754
Ph: (570) 368-2888
Fax: (570) 368-1722

Owner

11/11/08

11/17/08

Sheet Name

Details

Sheet


4 of 4

THIS DRAWING AND THE INFORMATION SHOWN THEREON IS THE PROPERTY OF THE LUNDY CONSTRUCTION CO., AND MAY NOT BE COPIED OR USED EXCEPT WITH THE PERMISSION OF LUNDY CONSTRUCTION CO.

© 2008—LUNDY CONSTRUCTION CO.




▲ LUNDY CONSTRUCTION CO.

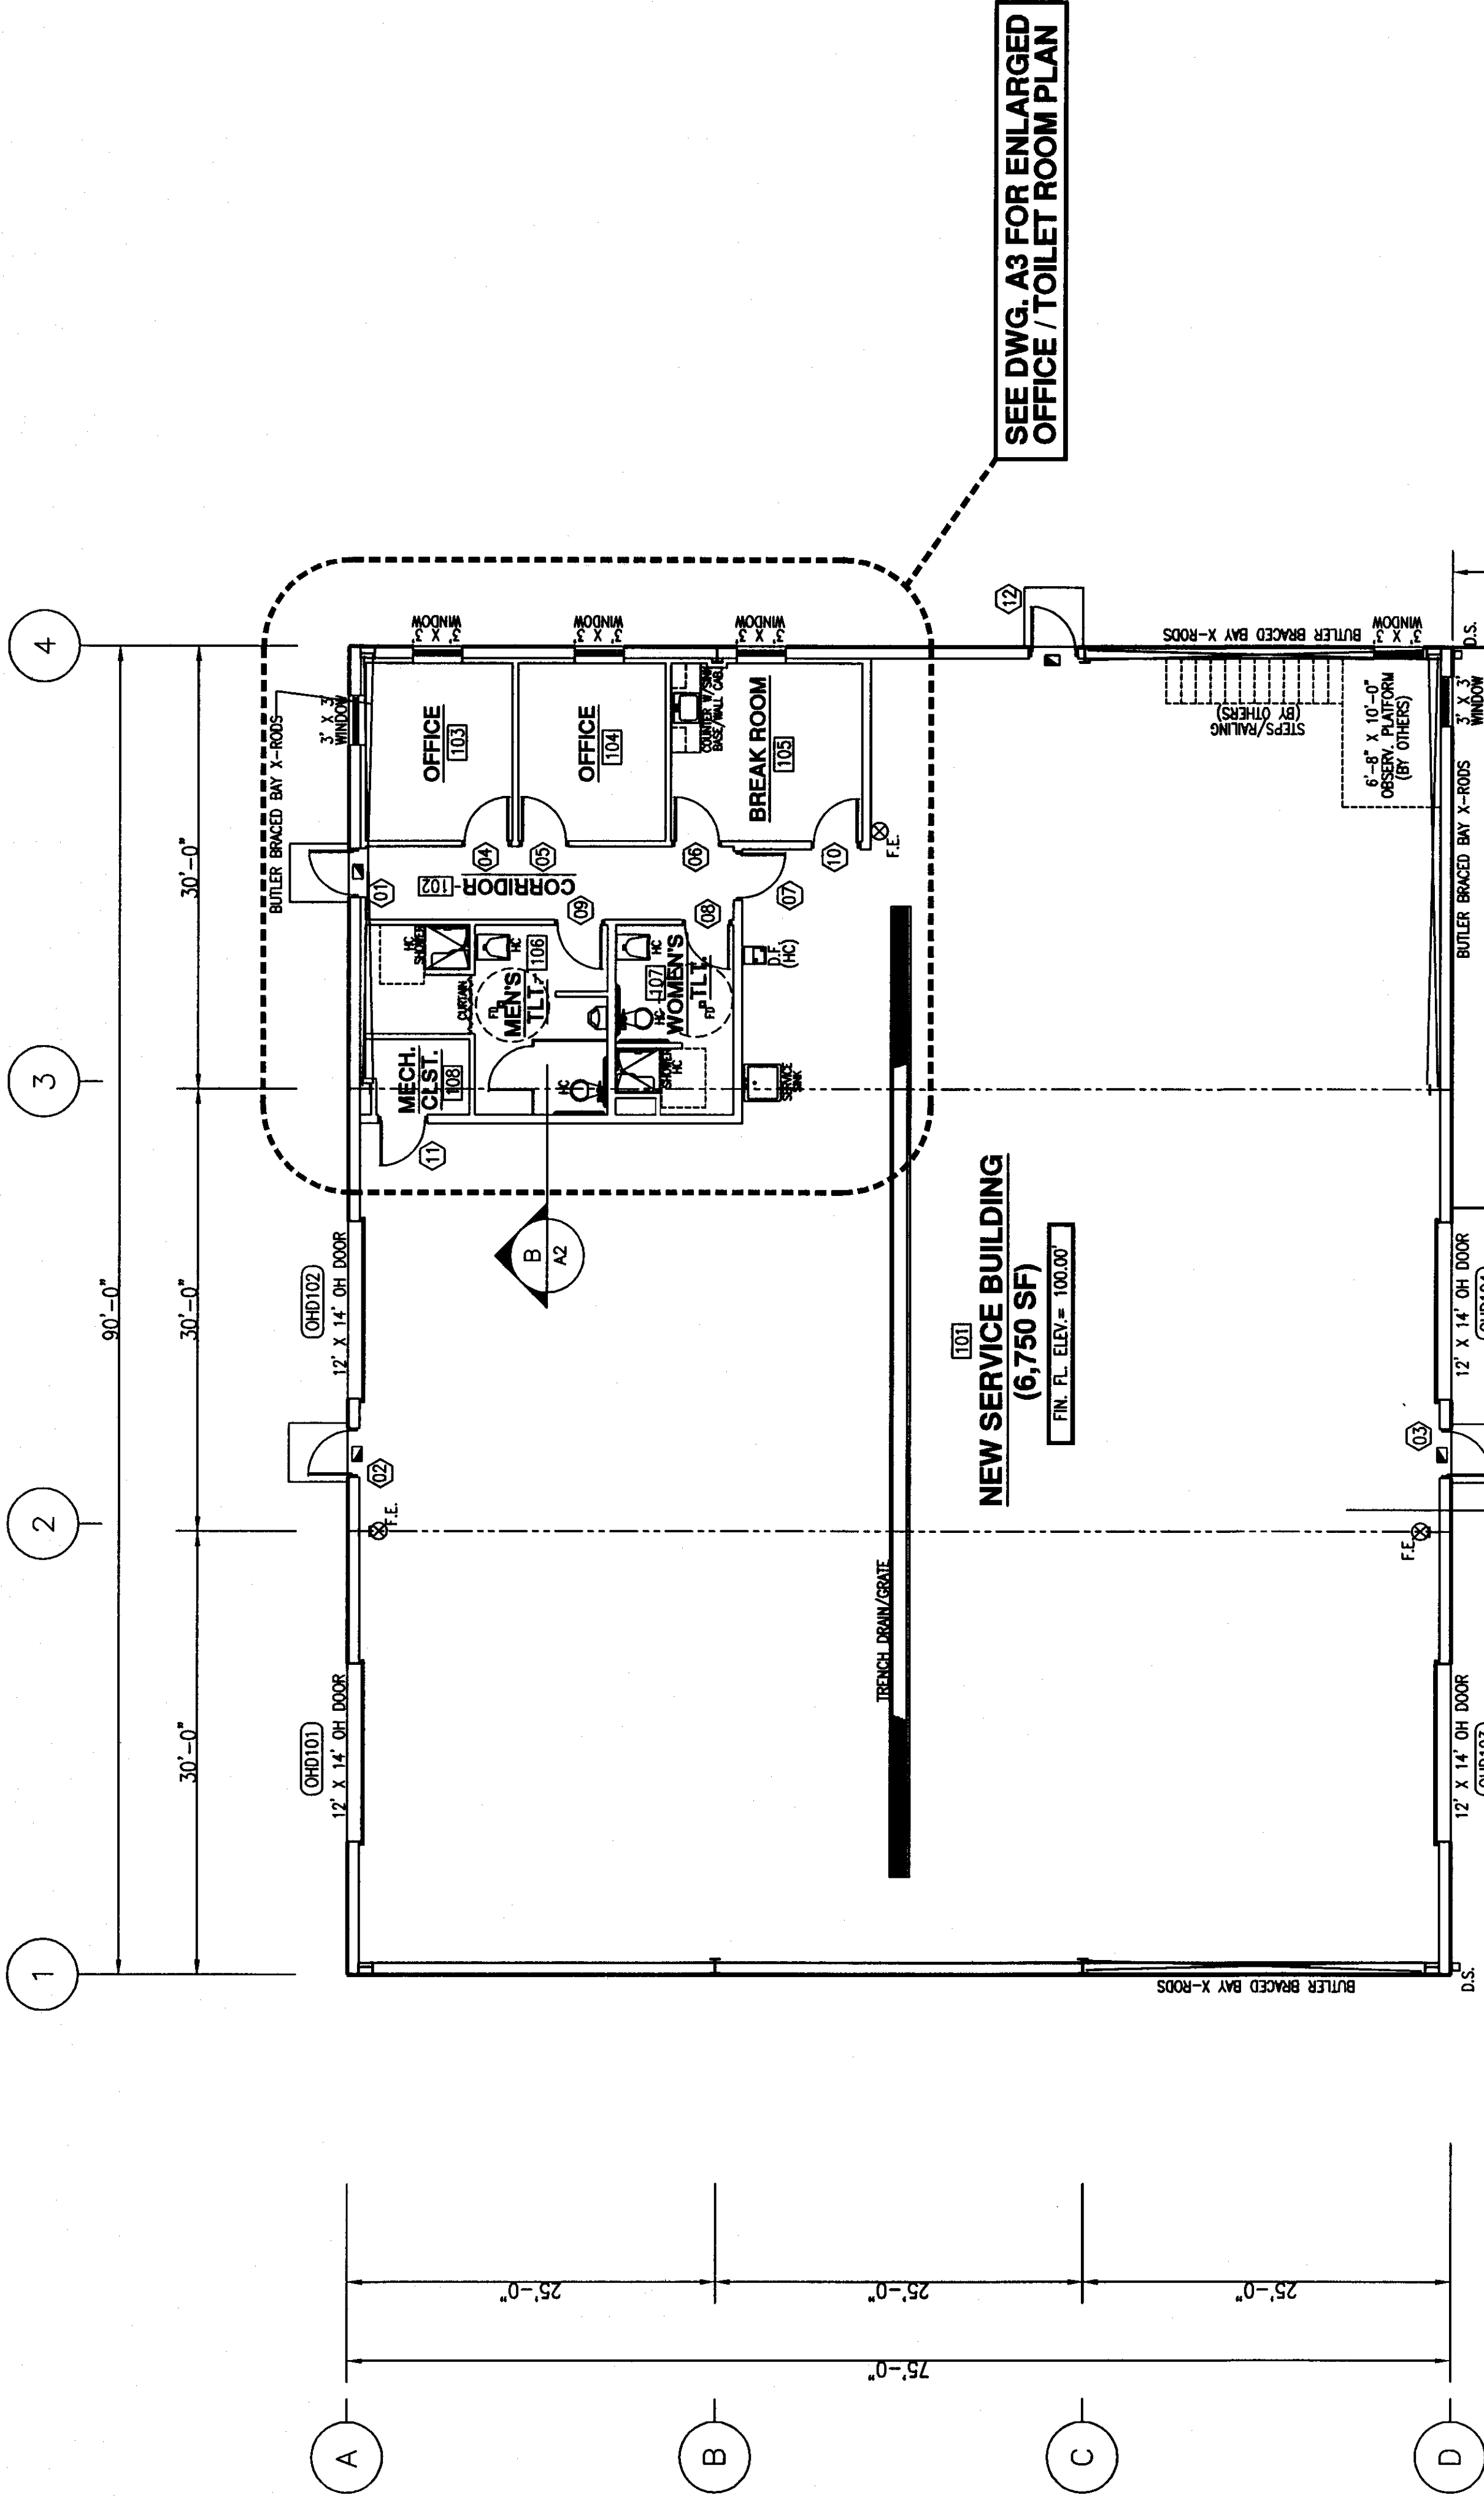


SEE DWG. A3 FOR ENLARGED OFFICE / TOILET ROOM PLAN

NEW SERVICE BUILDING
(6,750 SF)
FIN. FL. ELEV. = 100.00'


FLOOR PLAN
SCALE: 1/8" = 1'

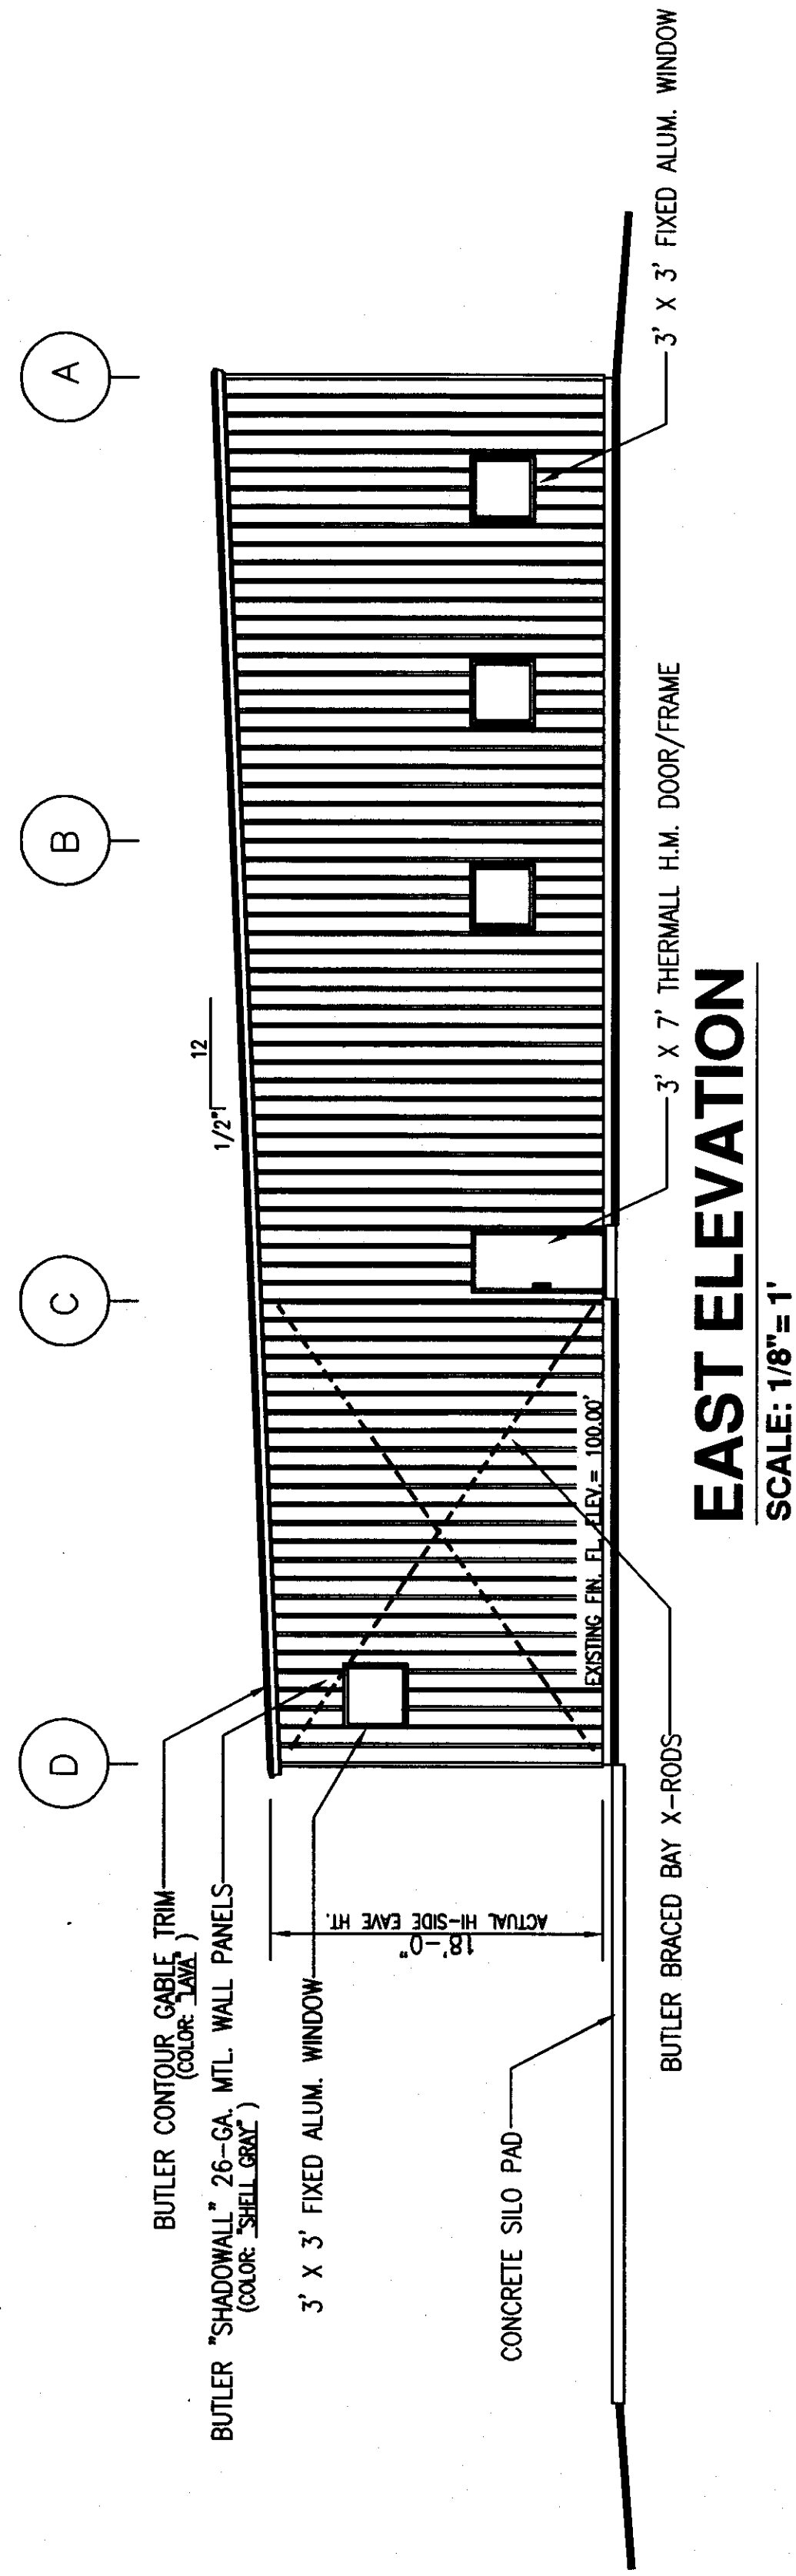


EAST ELEVATION
SCALE: 1/8" = 1'

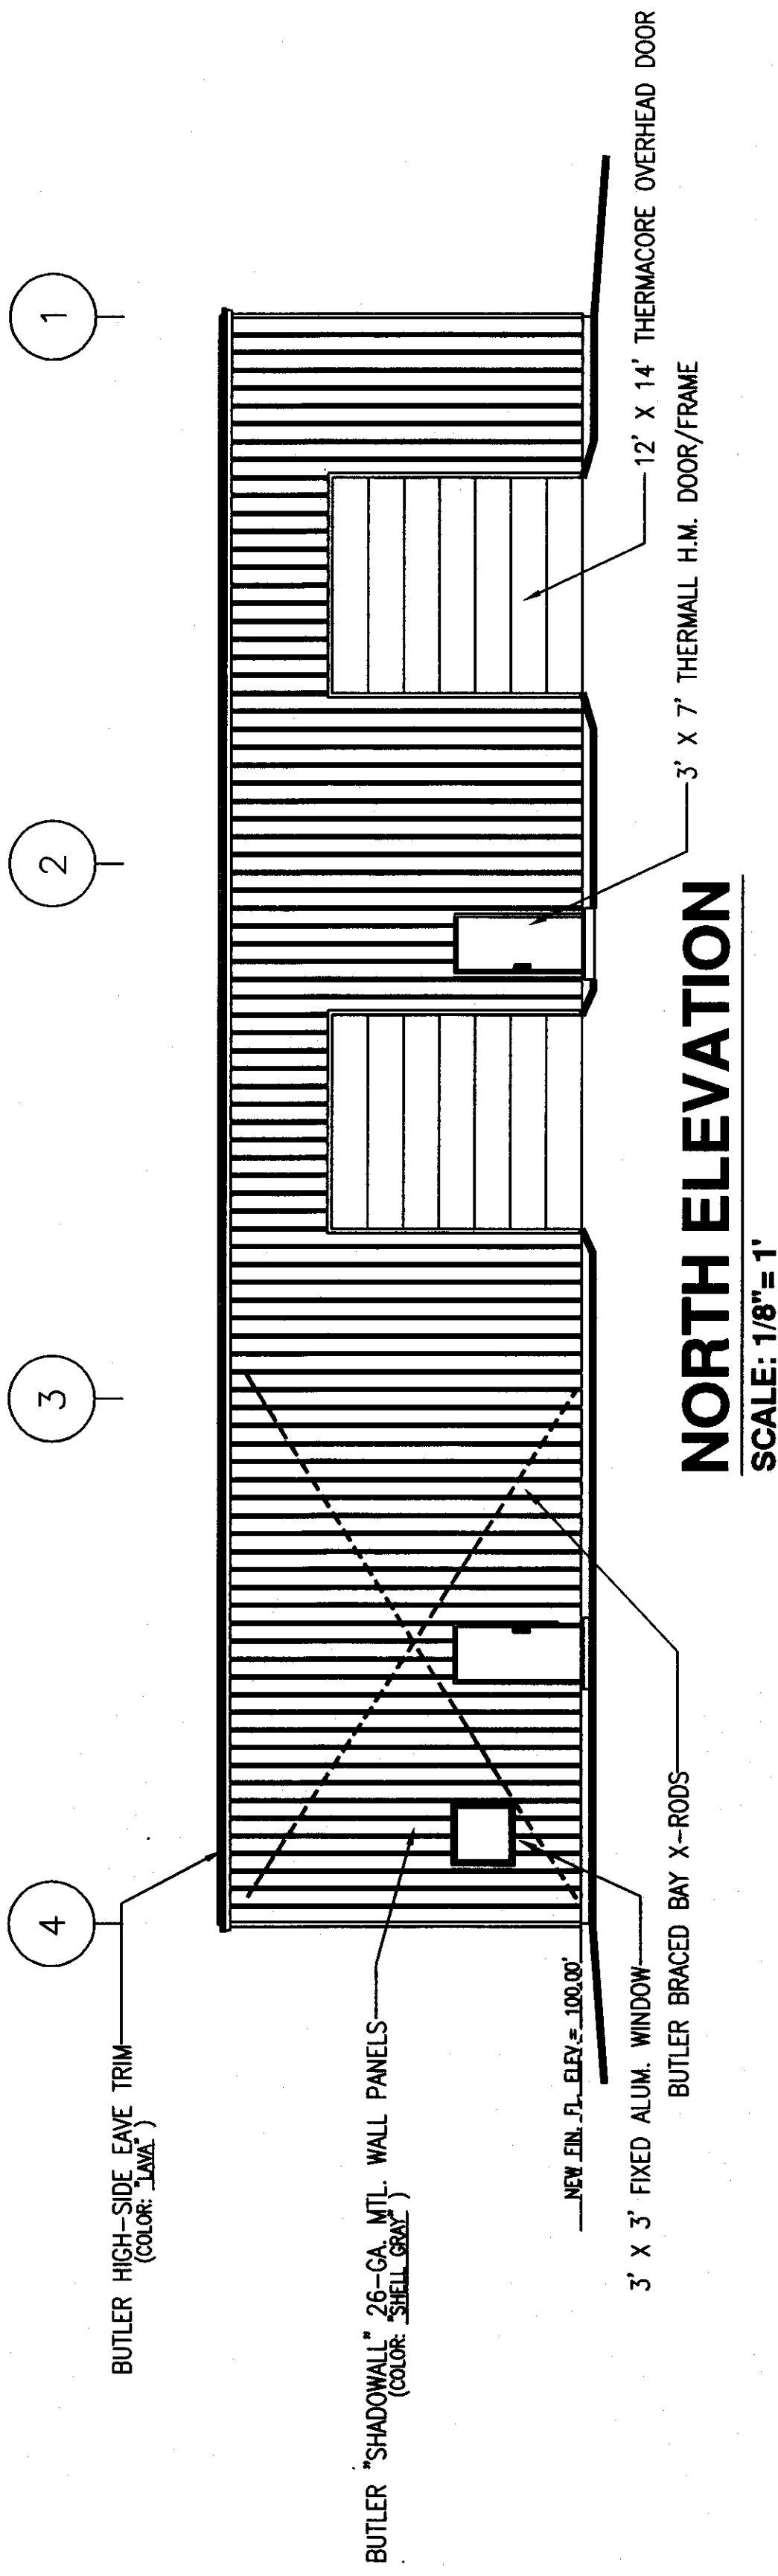

NORTH ELEVATION
SCALE: 1/8" = 1'

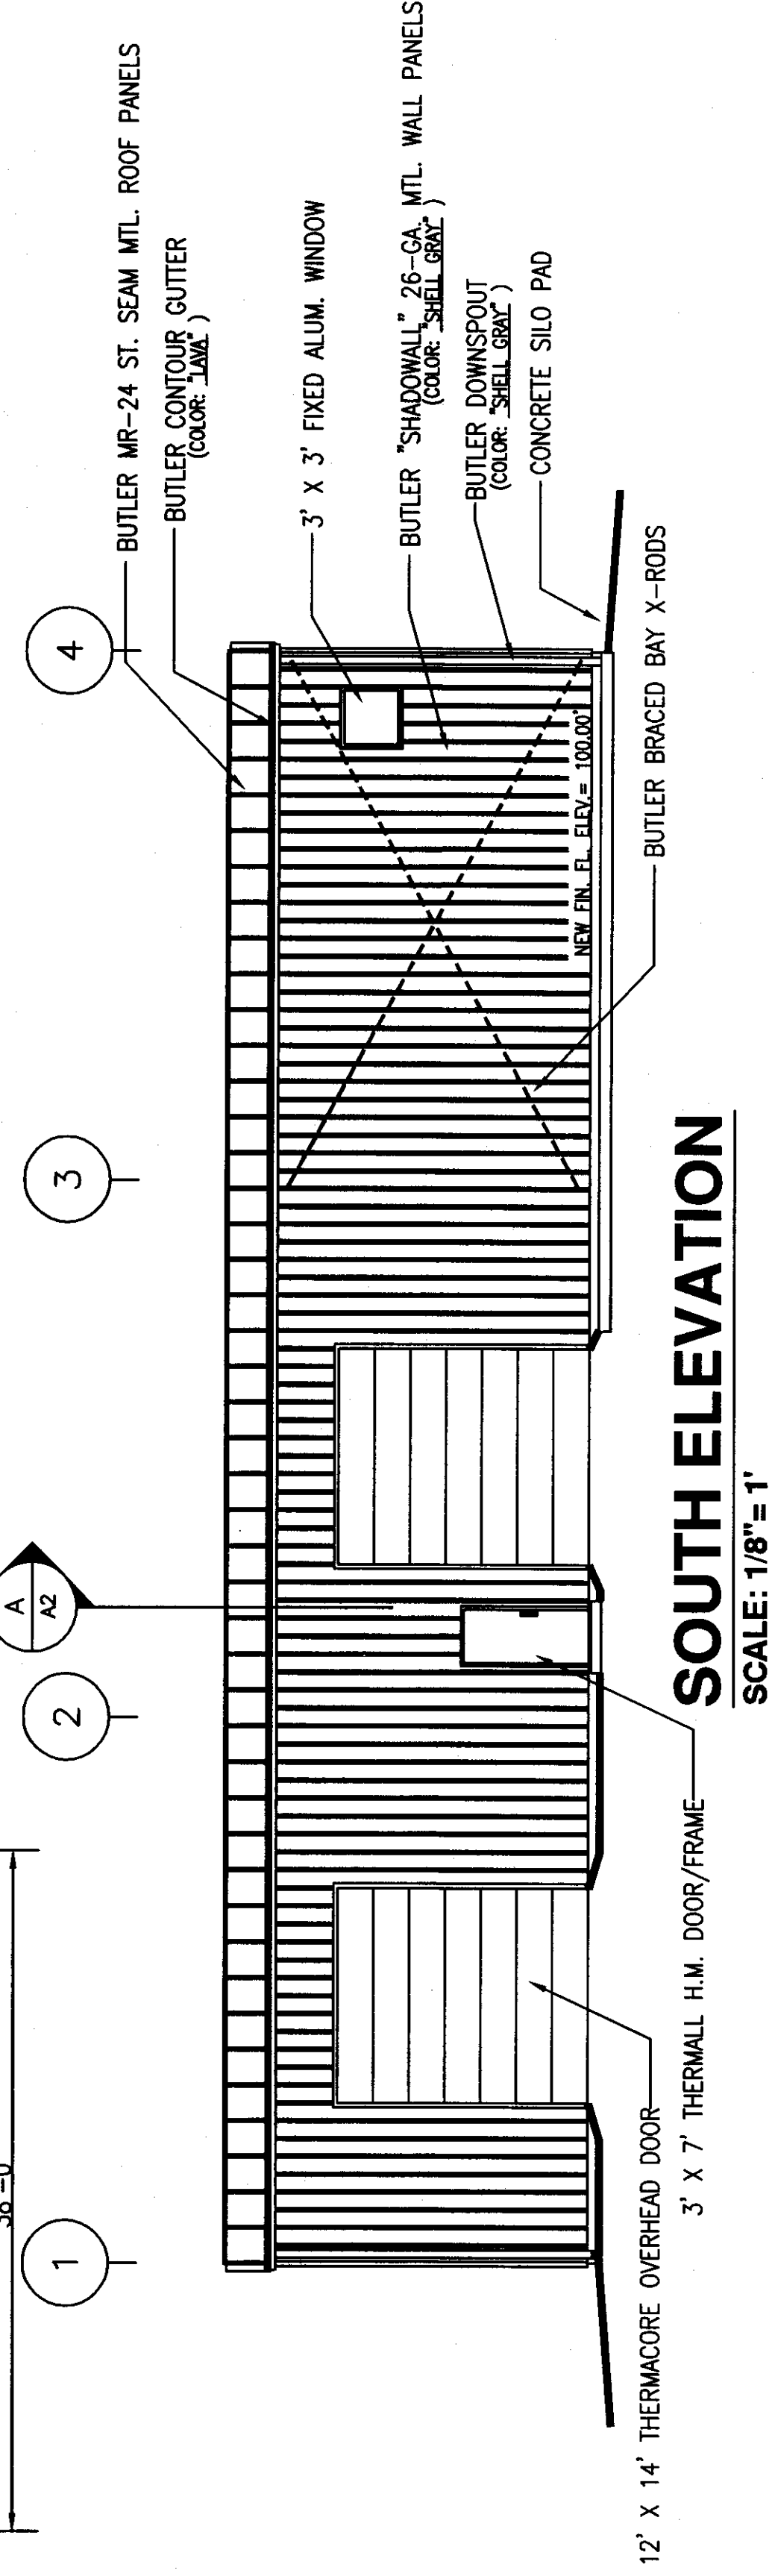

SOUTH ELEVATION
SCALE: 1/8" = 1'

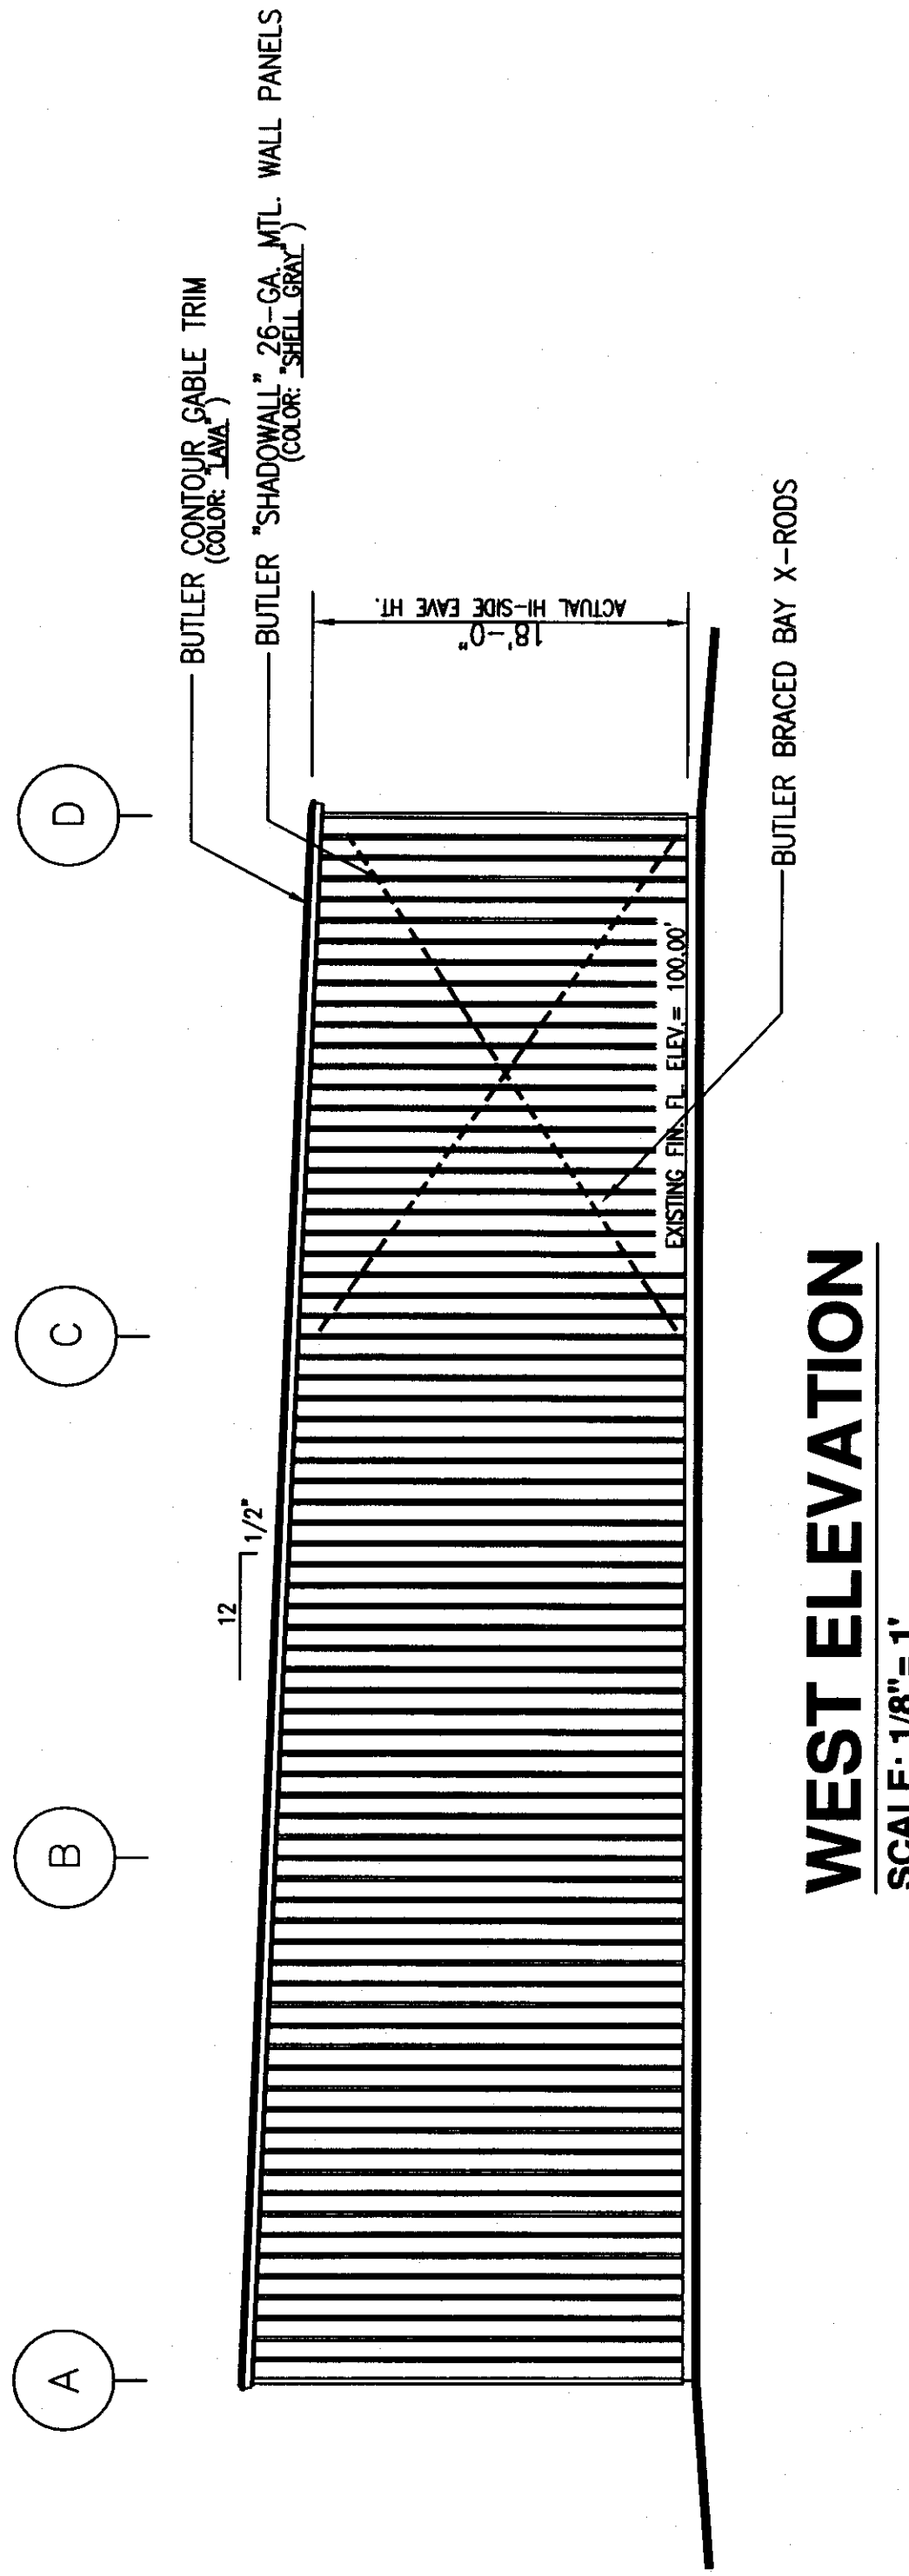

WEST ELEVATION
SCALE: 1/8" = 1'

PLOT DATE: JAN. 6, 2009

▲ LUNDY CONSTRUCTION CO.

SAFETY FIRST, LAST, AND ALWAYS

PROJECT
WILLIAMSPORT PROPERTIES, INC.
(PROPOSED SERVICE BUILDING)
MUNCY INDUSTRIAL PARK, MUNCY, PA (MUNCY CREEK TWP./LYCOMING CO.)

DATE: 11/14/08
SCALE: 1/8" = 1'
DRAWN BY: ML CHKD BY:
APPROVALS:

NO.	DATE	REVISION	BY
1	11/17/08	1.00	ML
2	11/17/08	2.00	ML
3	11/17/08	3.00	ML
100	11/17/08	100.00	ML

ISSUED
ENGINEER
FRANK B. LUNDY, P.E.
LUNDY CONSTRUCTION CO.
P.O. BOX 3278
WILLIAMSPORT, PA 17701
PHONE: (570)-323-8451

PROJECT
WILLIAMSPORT PROPERTIES, INC.
(PROPOSED SERVICE BUILDING)
MUNCY INDUSTRIAL PARK, MUNCY, PA (MUNCY CREEK TWP./LYCOMING CO.)

DATE: 11/14/08
SCALE: 1/8" = 1'
DRAWN BY: ML CHKD BY:
APPROVALS:

PROJECT
WILLIAMSPORT PROPERTIES, INC.
(PROPOSED SERVICE BUILDING)
MUNCY INDUSTRIAL PARK, MUNCY, PA (MUNCY CREEK TWP./LYCOMING CO.)

DRAWING TITLE
PROJECT
WILLIAMSPORT PROPERTIES, INC.
(PROPOSED SERVICE BUILDING)
MUNCY INDUSTRIAL PARK, MUNCY, PA (MUNCY CREEK TWP./LYCOMING CO.)

ARCH 87 AND REACH RD.
WILLIAMSPORT, PA 17701
PHONE: (570)-323-8451
FAX: (570)-323-8458

LUNDY CONSTRUCTION
P.O. BOX 3278
WILLIAMSPORT, PA 17701
PHONE: (570)-323-8451
FAX: (570)-323-8458

DRAWING NO.
A1



FOUNDATION SCHEDULE

[illegible]

SECTION X


TYPICAL CONTROL JOINT

6" CONCRETE FLOOR SLAB
W/FIBERMESH REINFORCING
(• SERVICE AREAS)


4" CONCRETE FLOOR SLAB
W/FIBERMESH REINFORCING

—SOFCUT SAW CONTROL JOINT


THE DRAWING AND THE INFORMATION SHOWN THEREON IS THE PROPERTY OF THE LUNDY CONSTRUCTION CO. AND IS NOT TO BE REPRODUCED OR USED EXCEPT WITH THE PERMISSION OF LUNDY CONSTRUCTION CO.
© 2008-LUNDY CONSTRUCTION CO.

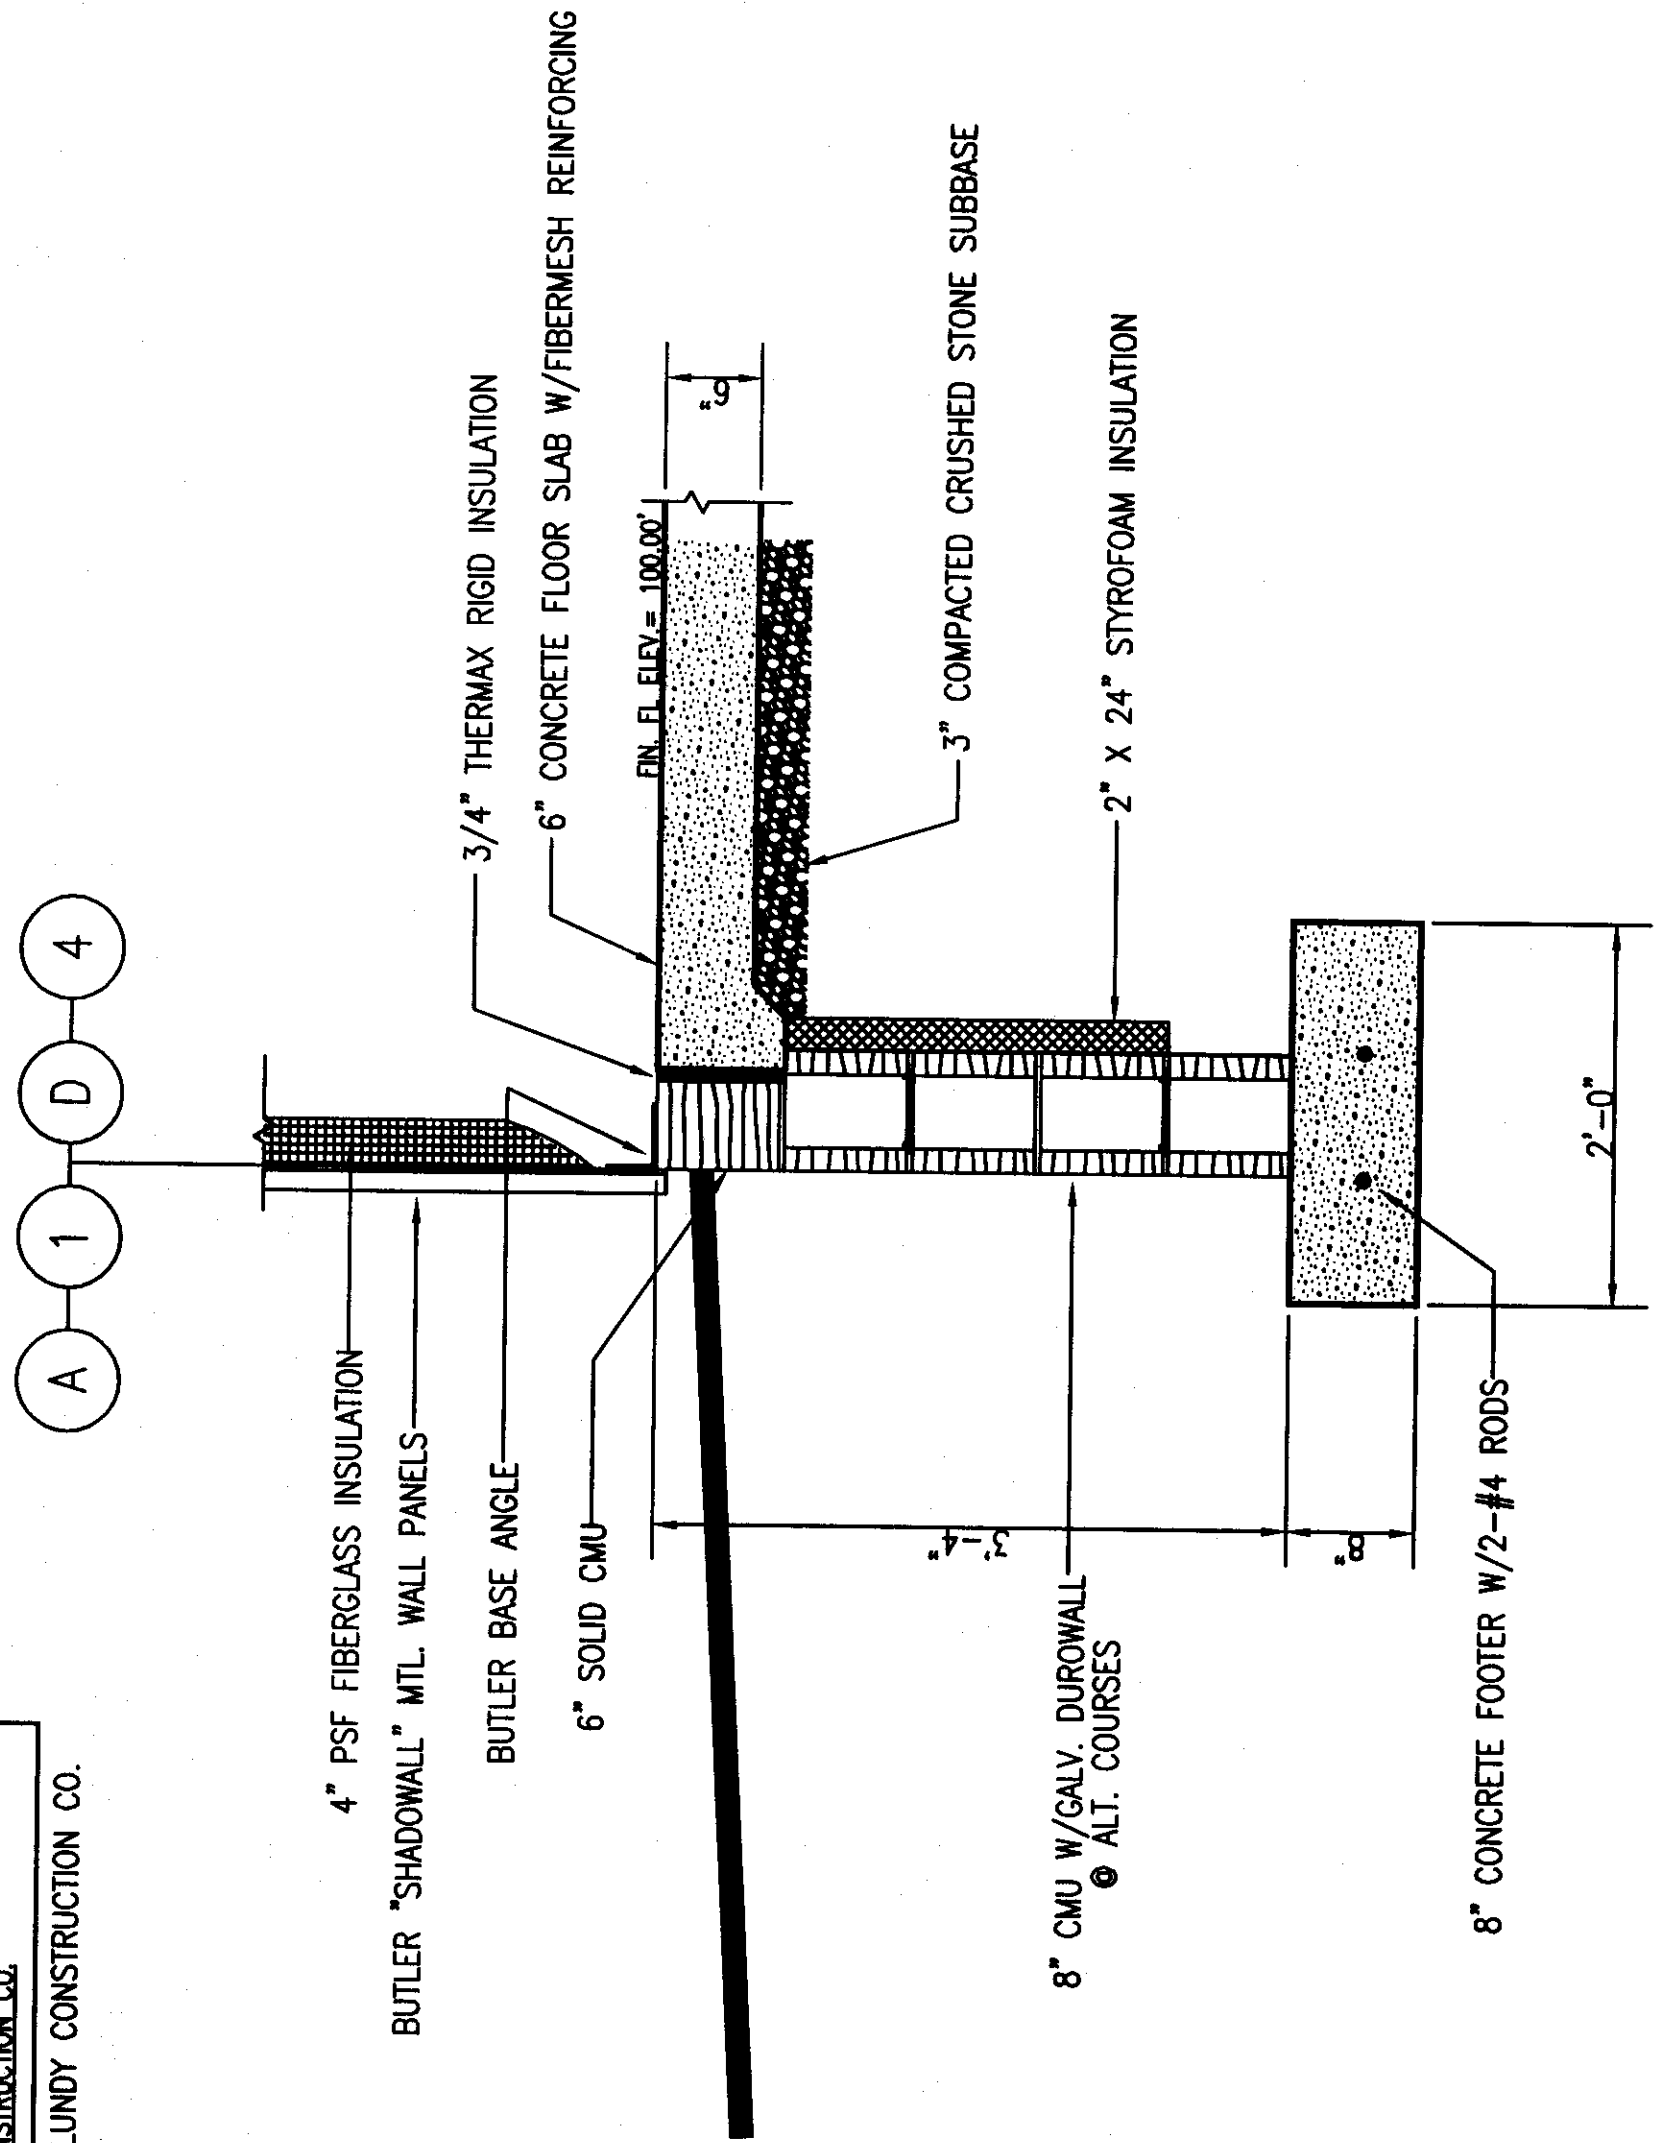


SECTION C
SCALE: 1"= 1'

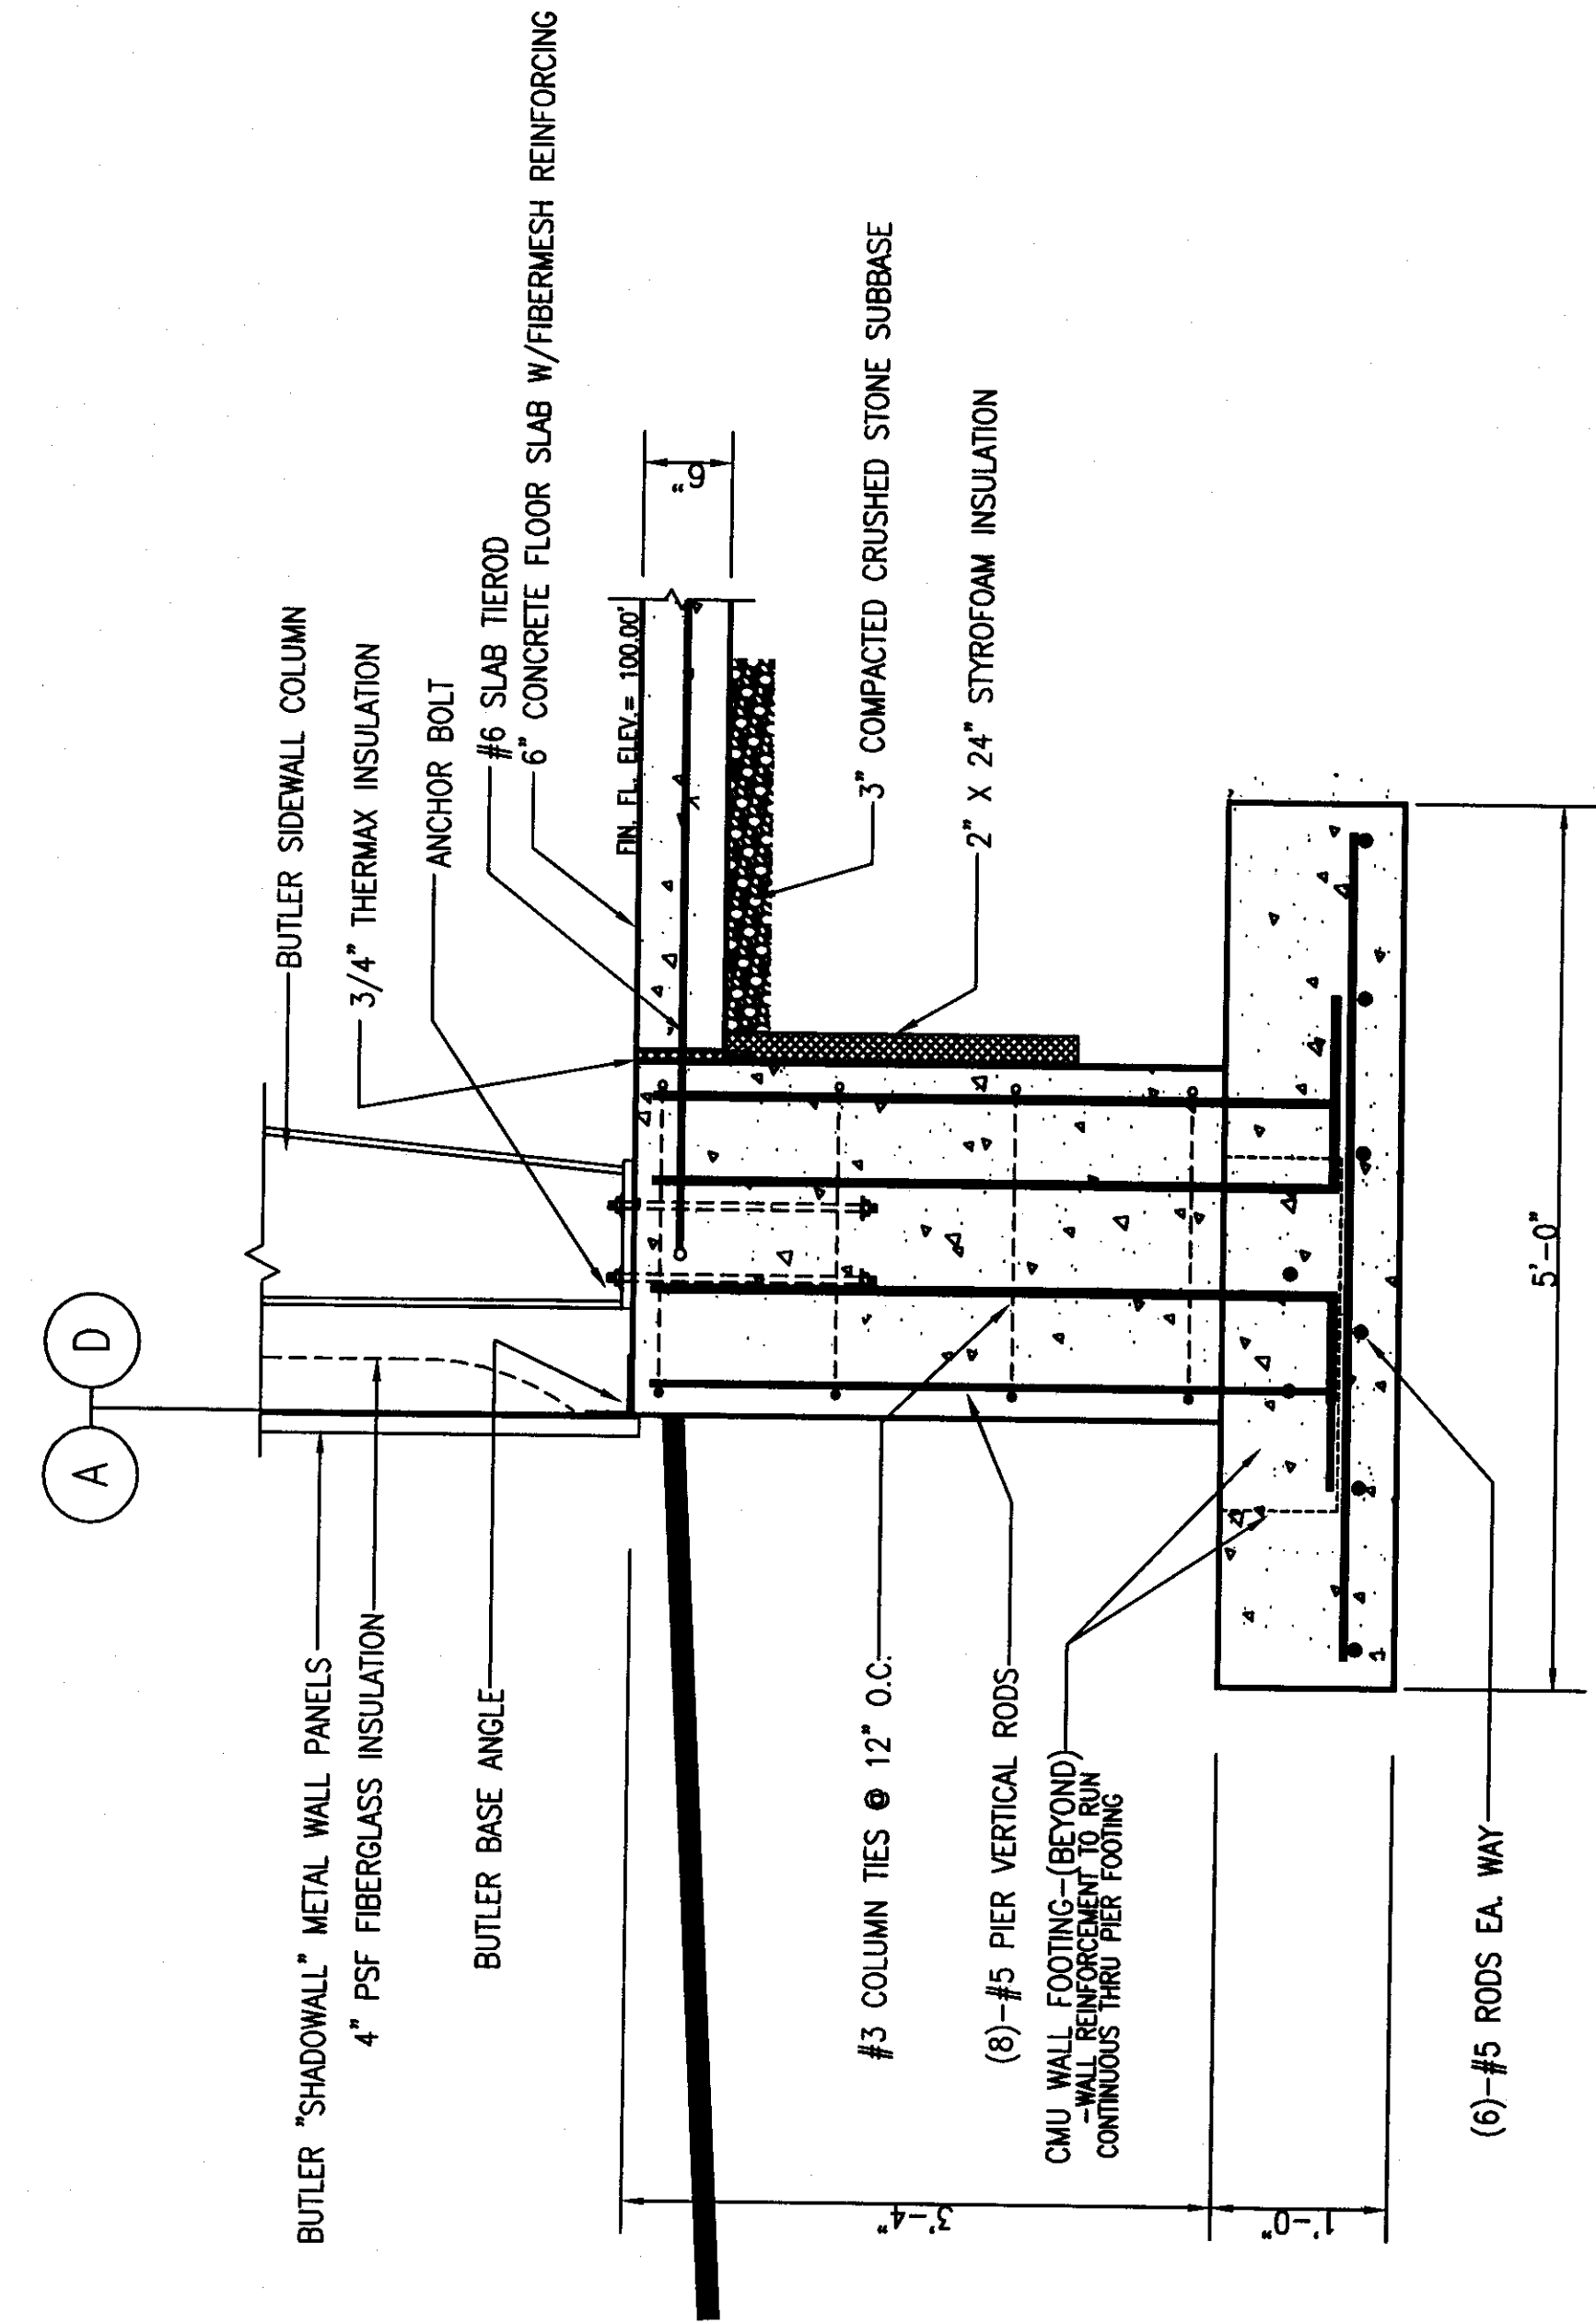

SECTION D
SCALE: 1"= 1'

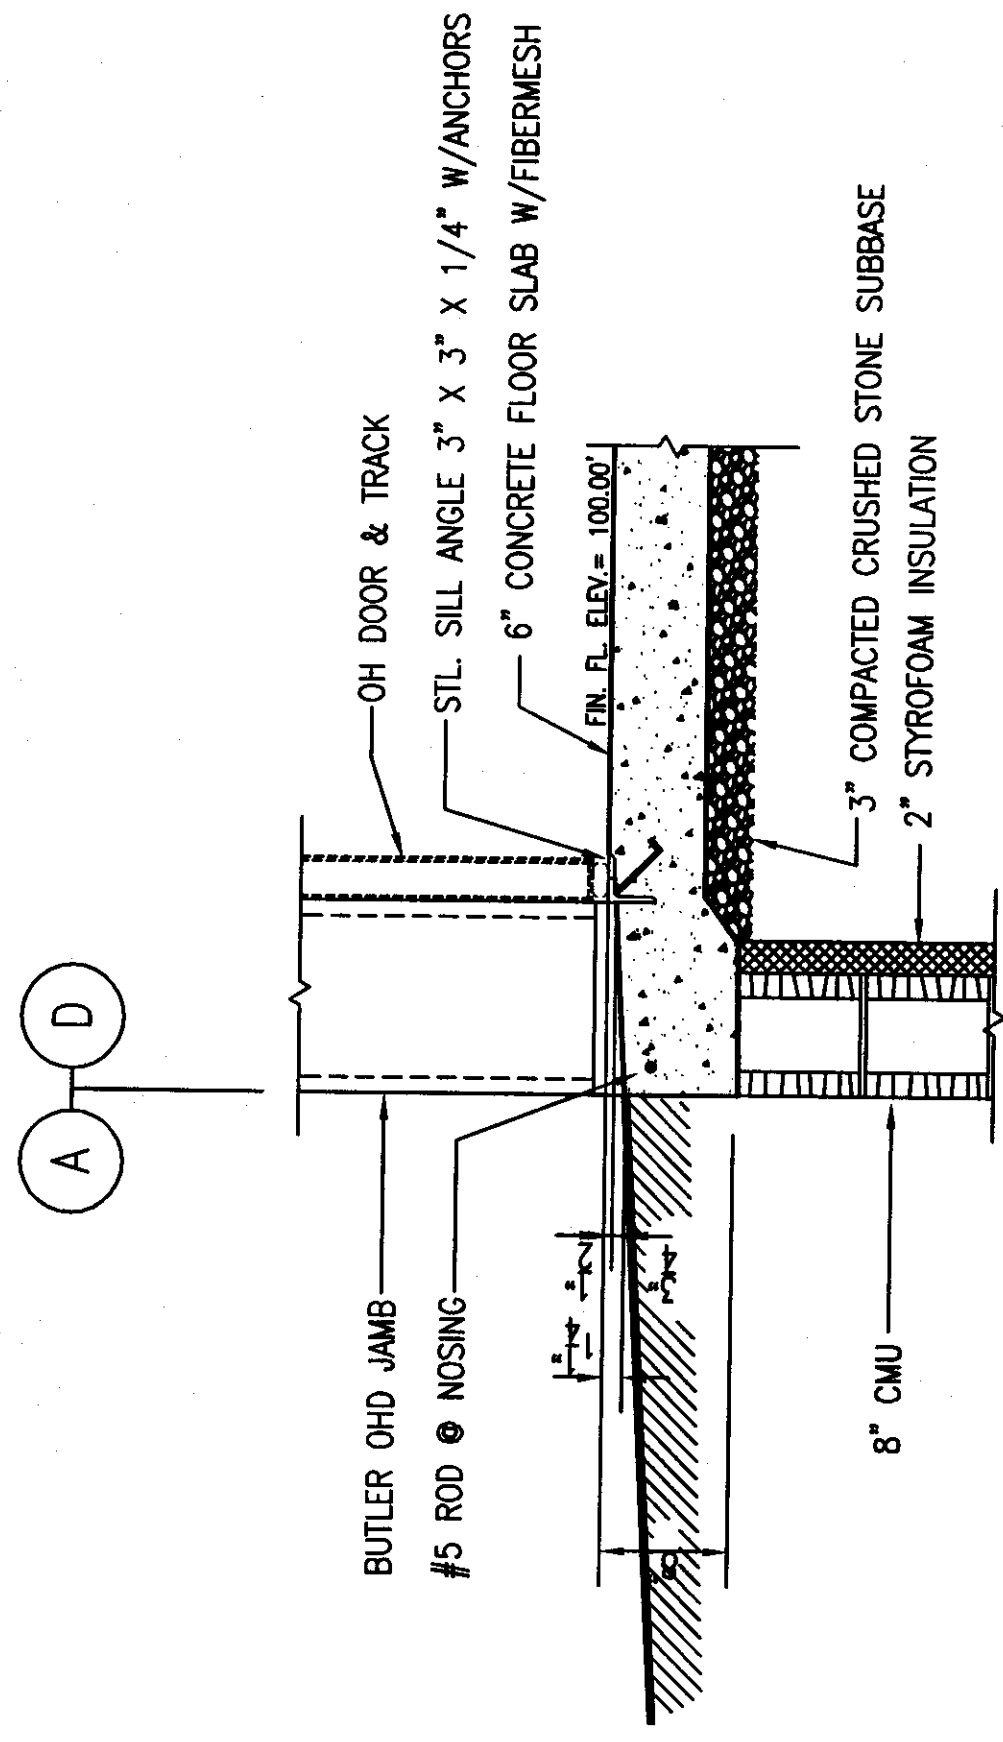


SECTION E
SCALE: 1"= 1'

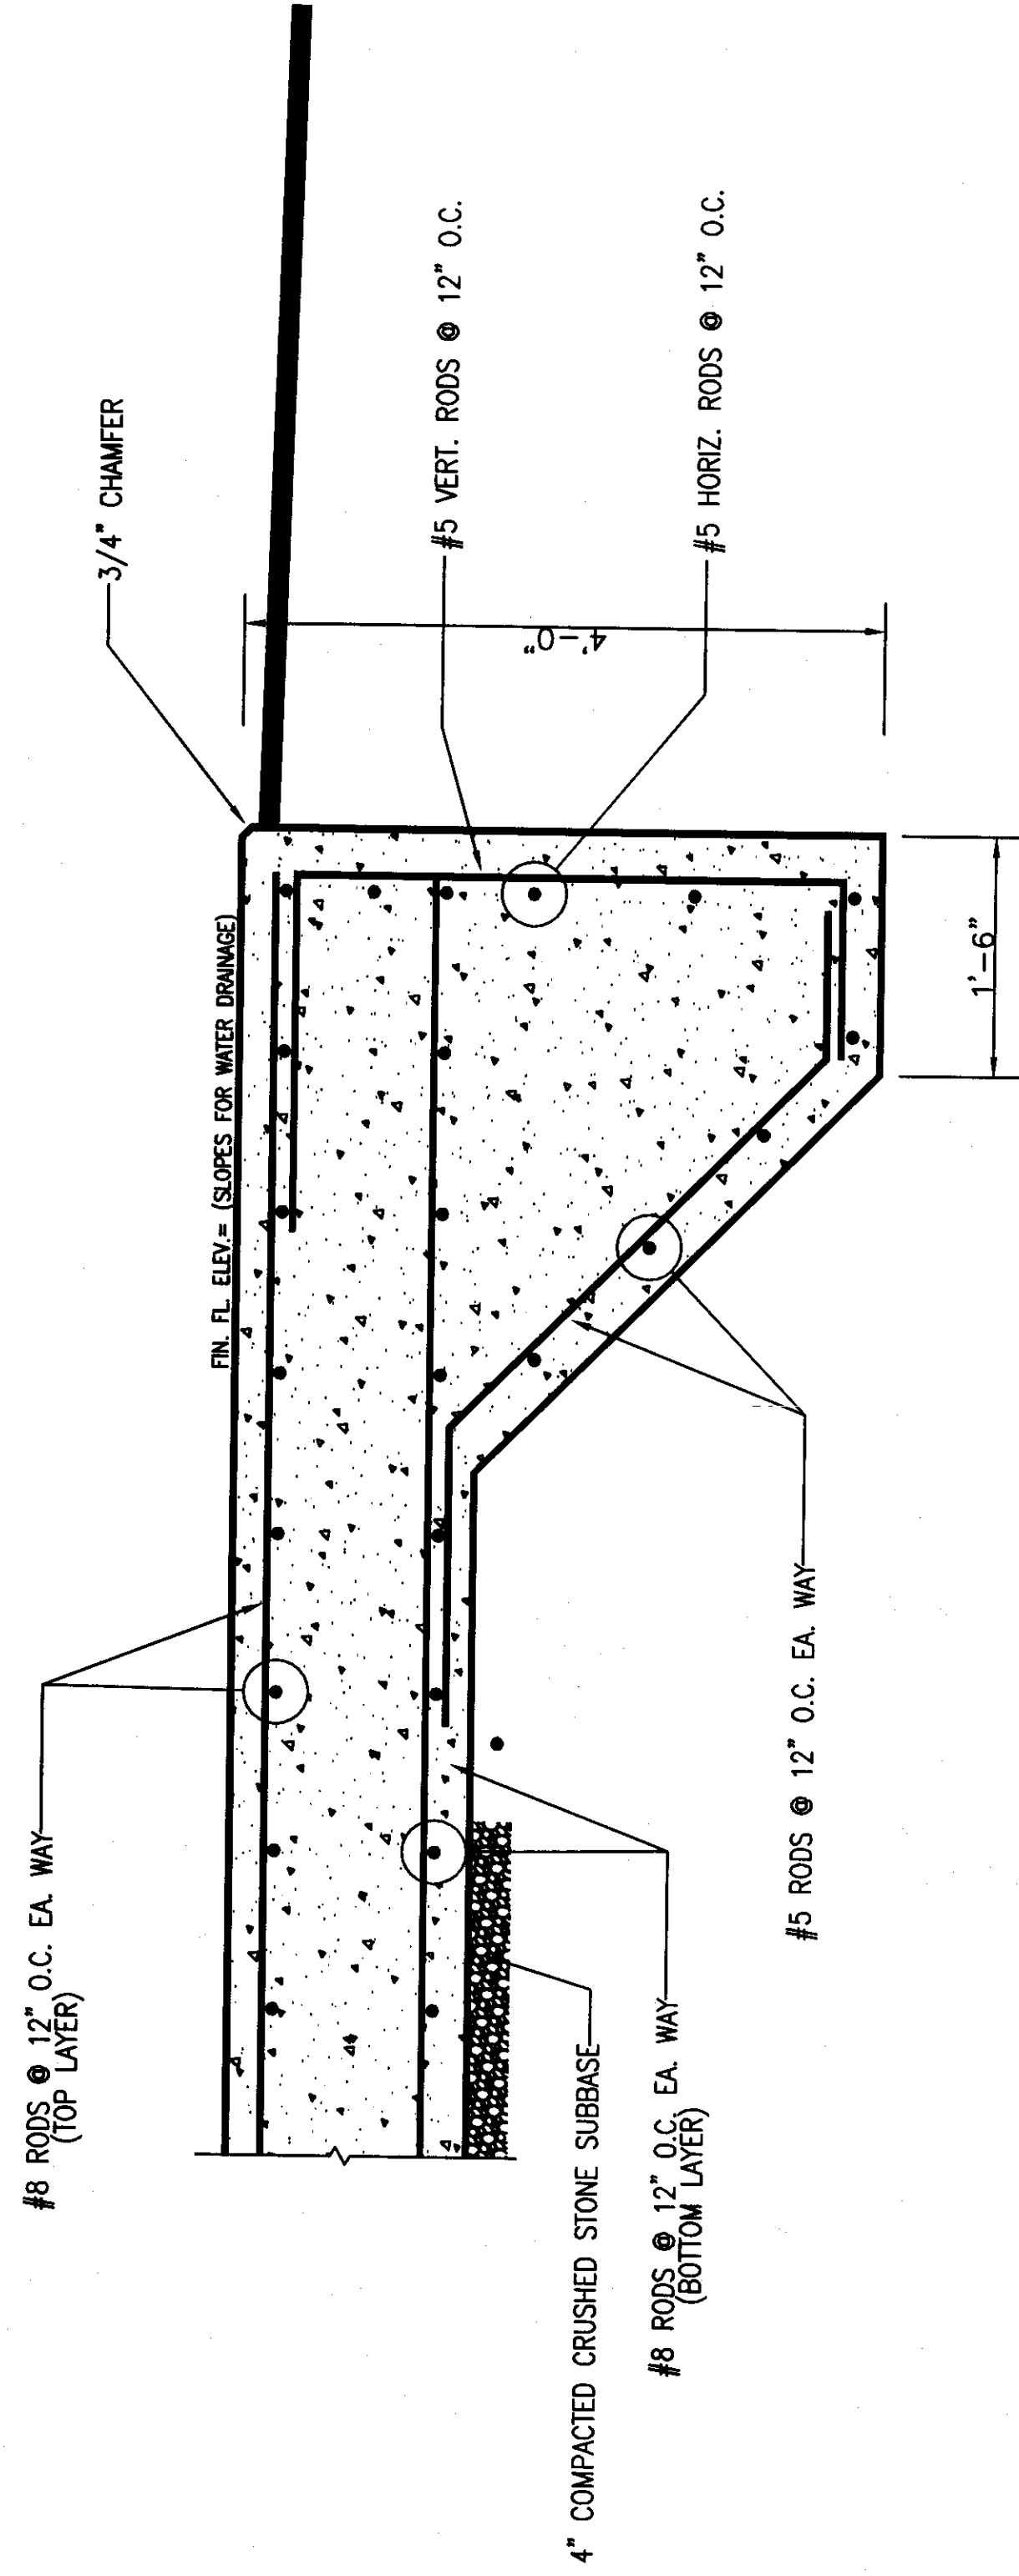

SECTION F
SCALE: 1"= 1'

PLOT DATE: NOV. 18, 2008

SAFETY FIRST, LAST, AND ALWAYS

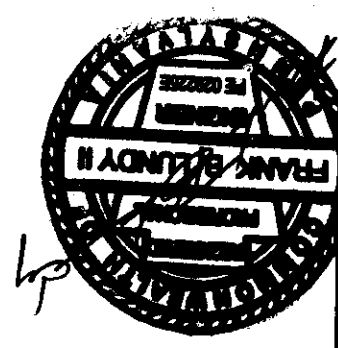

FRANK B. LUNDY, P.E.
LUNDY CONSTRUCTION CO.
P.O. BOX 3276
WILLIAMSPORT, PA 17701
PHONE: (570)-323-8451

ISSUED

NO.	DATE	REVISION	BY

PROJECT NO.
DATE: 11/18/08
SCALE: 1"= 1'
DRAWN BY: ML (CHKD BY: FR)
APPROVALS:

WILLIAMSPORT PROPERTIES, INC.
(PROPOSED SERVICE BUILDING)
MUNCY INDUSTRIAL PARK, MUNCY, PA (MUNCY CREEK TWP & LYCOMING CO.)

 
DRAWING TITLE
PROJECT

LUNDY CONSTRUCTION
ARCH ST. AND REACH RD.
P.O. BOX 3276
WILLIAMSPORT, PA 17701
PHONE: (570)-323-8451
FAX: (570)-323-8835

DRAWING NO.

F2





NEW SERVICE BUILDING
101
6,750 SF
FIN. FL. ELEV. 100.00'



PLUMBING FIXTURE SCHEDULE									
SYMBOL	MEQ.	MODEL	QTY	HW	W	1/2BT	1/2BT	REMARKS	
WC-1	ELBER	09-2176	1/2"	...	4"	1/2"	1/2"	WALL TOILET	
L-1	ELBER	09-2180	1/2"	...	4"	1/2"	1/2"	ADJ. TUB LAVATORY W/ CONSOLE	
BK-1	LACRO	808-8F8C	1/2"	1/2"	2"	1/2"	...	30" X 48" BARBER FREE SERVICE	
LACRO	LACRO	808-8F8C	1/2"	1/2"	2"	1/2"	...	30" X 48" BARBER FREE SERVICE	
L-1	LACRO	101-1150	1/2"	...	2"	1/2"	...	ADJ. SINK W/ 2 TUBAL W/ WALL	
BK-1	SWAN	MP-37	1/2"	1/2"	2"	1/2"	...	SERVICE SINK	
RS-1	ELBER	B0181	1/2"	...	2"	1/2"	...	SINGLE BURN. KITCHEN SINK W/ 2 TUBAL	
ELAY	ELAY	EN504E	1/2"	...	2"	1/2"	...	30" X 48" BARBER FREE SERVICE	
DF-1	ELAY	EN504E	1/2"	...	2"	1/2"	...	30" X 48" BARBER FREE SERVICE	



HVAC & DUCTWORK PLAN
Scale: 1/4" = 1'-0"

GRILLE REGISTER & DIESELER SCHEDULE

GAS UNIT HEATER SCHEDULE

EXHAUST FAN SCHEDULEGAS ELBNAE I UNIT SCHEDUL ECONDENSING UNIT SCHEMATIC

CONNECT BY E.C.

